


**FLOOR PLAN**  
SCALE = 1/8" = 1'-0"

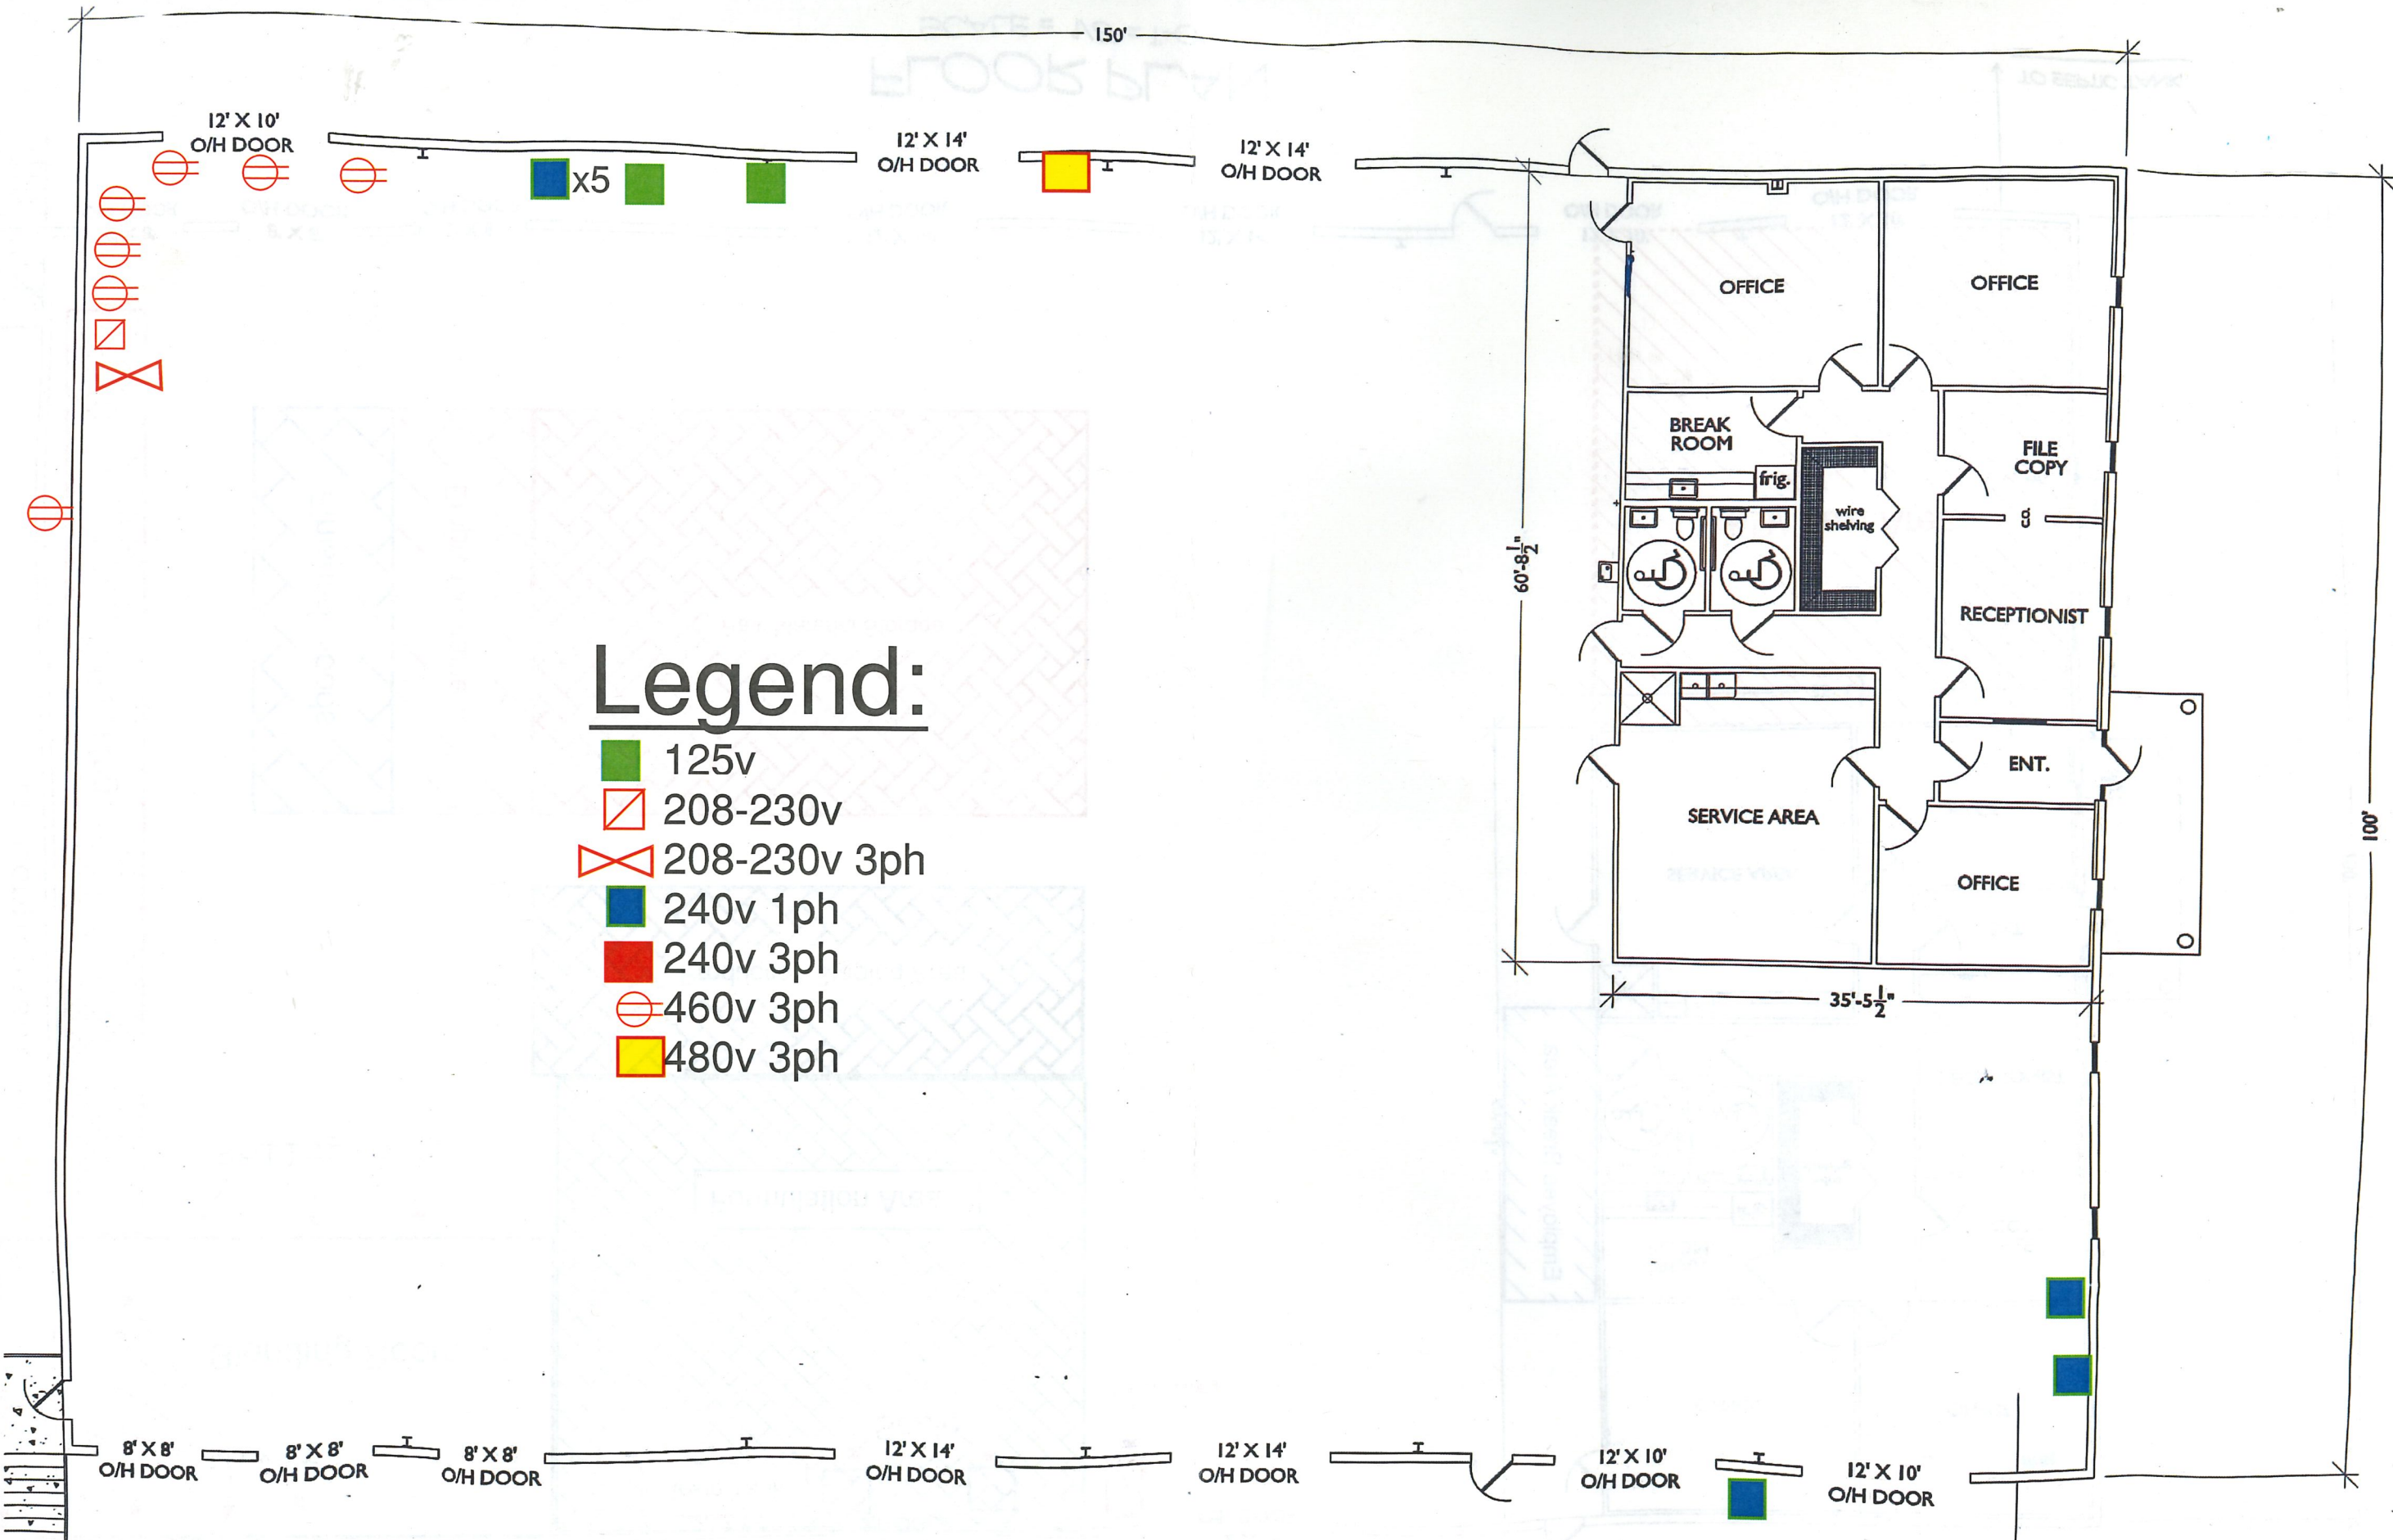

# Legend:

- 125v
- ▧ 208-230v
- ⊗ 208-230v 3ph
- 240v 1ph
- 240v 3ph
- ⊖ 460v 3ph
- 480v 3ph

# Electrical Layout

FLOOR PLAN  
SCALE = 1/8" = 1'-0"