

THE PRESTON

(Nunnally Farm Rd.)



390 BROGDON RD,
SUWANEE, GA. 30024

DESIGNER HEREBY EXPRESSLY RESERVES HIS COPYRIGHT AND OTHER PROPERTY RIGHT IN THESE PLANS. THESE PLANS AND DRAWINGS ARE NOT TO BE REPRODUCED, CHANGED OR COPIED IN ANY FORM OR MANNER WHATSOEVER WITHOUT FIRST OBTAINING THE EXPRESS WRITTEN PERMISSION AND CONSENT OF THE DESIGNER. NOR ARE THEY TO BE ASSIGNED TO ANY INTERESTS WITHOUT FIRST OBTAINING SAID WRITTEN PERMISSION AND CONSENT. DESIGN DRAWING CONTENTS SUBJECT TO ALL APPLICABLE CODES, AND APPROVAL BY A LICENSED ENGINEER AND OR ARCHITECT.

SUB-DIVISION Nunnally Farm
LOT # _____

RELEASED FOR CONSTRUCTION

REVISED

THE PRESTON

JOB NO. NA DRAWN GC
DATE 2/10/2023 CHECKED DB
SCALE: AS NOTED APPROV. DB

COVER SHEET

APPROVED BY: DAVID BOWEN

DATE: _____

SHEET NO.

C0.0

SHEET: XX OF XX



ELEVATION A



ELEVATION B



ELEVATION C


BUILDING CODE ANALYSIS

USE GROUP: CONSTRUCTION CLASS: HEIGHT & AREA LIMITATION: EMERGENCY ESCAPE:	SINGLE FAMILY DWELLING UNPROTECTED 2 STORY MAXIMUM HGT. 35 FT. EGRESS OR RESCUE WINDOWS FROM SLEEPING ROOMS SHALL HAVE A MINIMUM OF 5.7 SQ. FT.
GARAGE / HOUSE CEILING/ HOUSE ASSEMBLY:	12" GYPSUM BD. WALL & CEILING W/ 20 MINUTE GARAGE / HOUSE DOOR
DESIGN LOADS:	LIVE LOAD: SLEEPING + 30 PSF NON-SLEEPING + 40 PSF DECKS + 40 PSF DEAD LOAD + 10 PSF BASIC WIND SPEED + 80 MPH STAIR LOAD + 40 PSF ROOF LIVE LOAD + 20 PSF LATERAL SOIL PRESSURE + 30 PCF (ASSUMED)
ATTIC VENTILATION: (EXAMPLE)	2398 SF. / 300 = 7.99 SF. FREE AREA REQ'D RIDGE VENT + 39 LF. X .025 FREE AREA/LF + 3.31 SF. PROVIDED SOFFIT VENT + 54 LF. X .045 FREE AREA/LF + 2.43 SF. PROVIDED
NOTE: VERIFY ALL APPLICABLE BUILDING CODES WITH STATE AND LOCAL JURISDICTION PRIOR TO CONSTRUCTION.	



DRAWING INDEX

C0.0	COVER SHEET
A11	ELEVATION 'A'
A111	ELEVATION 'A' W/ 3RD CAR GARAGE OPT.
A12	ELEVATION 'B'
A121	ELEVATION 'B' W/ 3RD CAR GARAGE OPT.
A13	ELEVATION 'C'
A131	ELEVATION 'C' W/ 3RD CAR GARAGE OPT.
A21	SIDES & REAR ELEVATIONS
A22	LEFT SIDE & REAR ELEV. W/ 3RD CAR GARAGE OPT.
A31	SLAB PLAN
A32	SLAB PLAN W/ 3RD CAR GARAGE OPT.
A41	MAIN FLOOR PLAN
A42	MAIN FLOOR PLAN W/ 3RD CAR GARAGE OPT.
A51	UPPER FLOOR PLAN
A61	ROOF PLANS
A71	ELECTRICAL PLAN

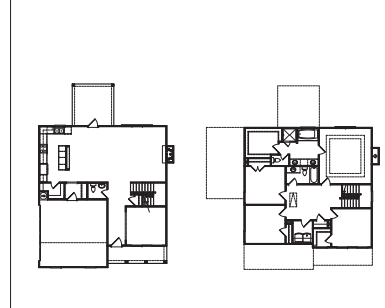FOOTPRINT



AREA CALCULATION

48' x 53' 
37' x 41' 

SQUARE FOOTAGE:	
MAIN LEVEL	1,015
OPT. BONUS ROOM	1,209
TOTAL HEATED	2,229
2 CAR GARAGE	393
FRONT PORCH	85
TOTAL FRAMED	2,106
OPT. COVERED PORCH	144
OPT. 3RD CAR GARAGE	226

DESIGNER HEREBY EXPRESSLY RESERVES HIS COPYRIGHT AND OTHER PROPERTY RIGHT IN THESE PLANS. THESE PLANS AND DRAWINGS ARE NOT TO BE REPRODUCED, CHANGED OR COPIED IN ANY FORM OR MANNER WHATSOEVER WITHOUT FIRST OBTAINING THE EXPRESS WRITTEN PERMISSION AND CONSENT OF THE DESIGNER. NOR ARE THEY TO BE ASSIGNED TO ANY INTERESTS WITHOUT FIRST OBTAINING SAID WRITTEN PERMISSION AND CONSENT. DESIGN DRAWING CONTENTS SUBJECT TO ALL APPLICABLE CODES, AND APPROVAL BY A LICENSED ENGINEER AND OR ARCHITECT.

SUB-DIVISION Nunnally Farm
LOT #

RELEASED FOR CONSTRUCTION

REVISED

THE PRESTON

JOB NO.	NA	DRAWN	GC
DATE	2/10/2023	CHECKED	DB
SCALE:	AS NOTED	APPROV.	DB

FRONT ELEVATION 'A'


APPROVED BY: DAVID BOWEN

DATE:

SHEET NO.

A1.1


SHEET: XX OF: XX

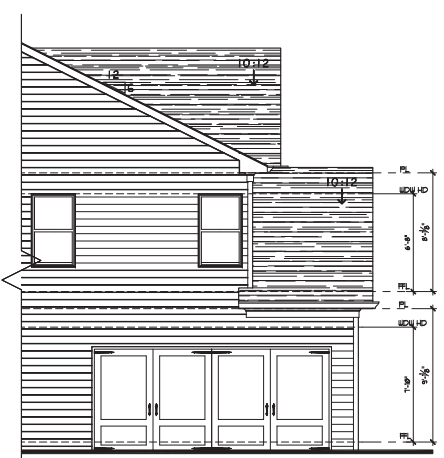


4 Left Side Elevation 'A'
ALL SCALE: 1/4" = 1'-0"




1 Front Elevation 'A'
ALL SCALE: 1/4" = 1'-0"

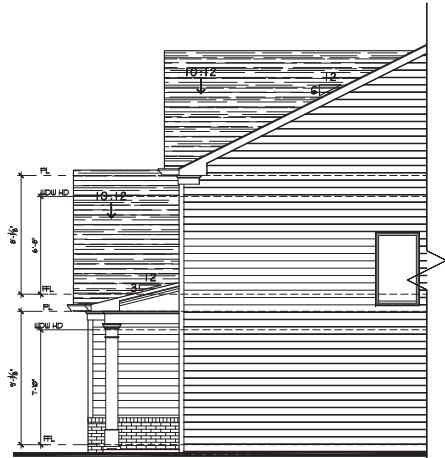

5 Right Side Elevation 'A'
ALL SCALE: 1/4" = 1'-0"

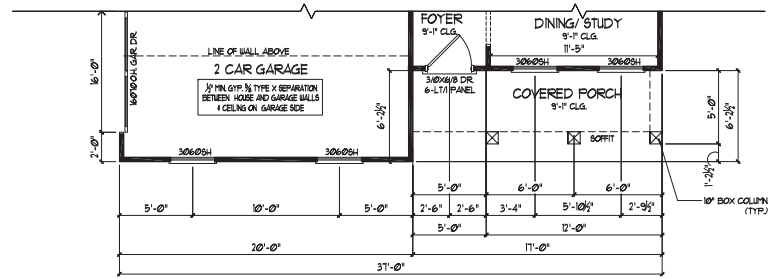

2 1st Floor Plan Elevation 'A'
ALL SCALE: 1/4" = 1'-0"

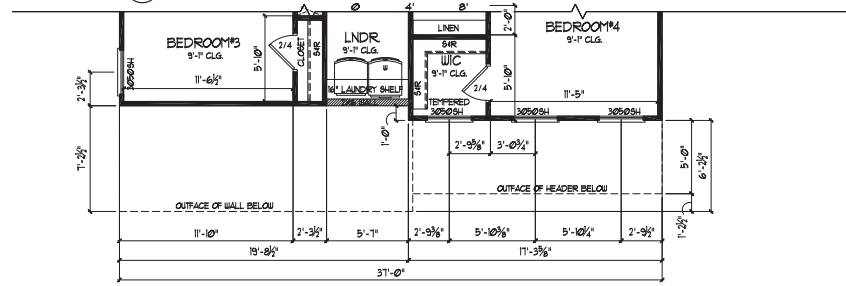

3 2nd Floor Plan Elevation 'A'
ALL SCALE: 1/4" = 1'-0"



390 BROGDON RD.,
SUWANEE, GA. 30024

DESIGNER HEREBY EXPRESSLY RESERVES HIS COPYRIGHT AND OTHER PROPERTY RIGHT IN THESE PLANS. THESE PLANS AND DRAWINGS ARE NOT TO BE REPRODUCED, CHANGED OR COPIED IN ANY FORM OR MANNER WHATSOEVER WITHOUT FIRST OBTAINING THE EXPRESS WRITTEN PERMISSION AND CONSENT OF THE DESIGNER. NOR ARE THEY TO BE ASSIGNED TO ANY INTERESTS WITHOUT FIRST OBTAINING SAID WRITTEN PERMISSION AND CONSENT. DESIGN DRAWING CONTENTS SUBJECT TO ALL APPLICABLE CODES, AND APPROVAL BY A LICENSED ENGINEER AND OR ARCHITECT.

SUB-DIVISION Nunnally Farm
LOT # _____

RELEASED FOR CONSTRUCTION

REVISED

THE PRESTON

JOB NO.	NA	DRAWN	GC
DATE	2/10/2023	CHECKED	DB
SCALE:	AS NOTED	APPROV.	DB

FRONT ELEVATION 'A'
W/ 3RD CAR GARAGE OPT.

APPROVED BY: DAVID BOWEN

DATE: _____


SHEET NO.

A1.1.1


SHEET: XX OF XX



1 Front Elevation 'A' w/ 3rd Car Garage Opt.-Front entry
ALL SCALE: 1/4" = 1'-0"

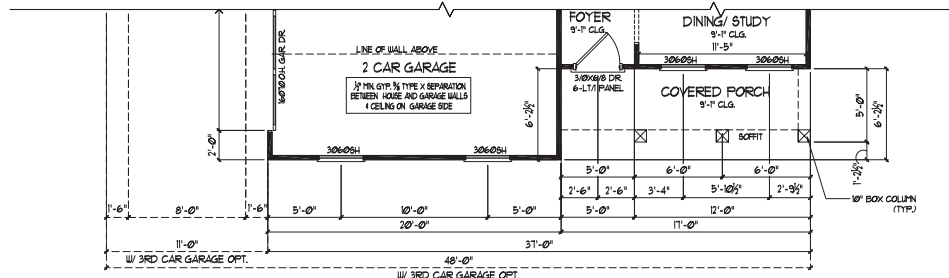

2 1st Floor Plan Elevation 'A'
ALL SCALE: 1/4" = 1'-0"

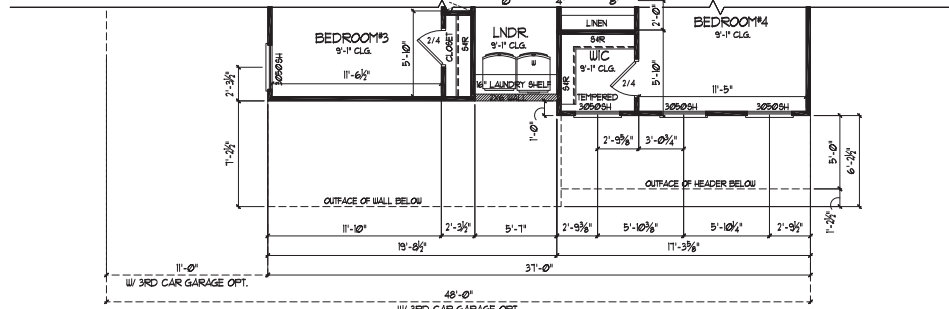


3 2nd Floor Plan Elevation 'A'
ALL SCALE: 1/4" = 1'-0"




4 Left Side Elevation 'B'
A12 SCALE: 1/4" = 1'-0"




1 Front Elevation 'B'
A12 SCALE: 1/4" = 1'-0"

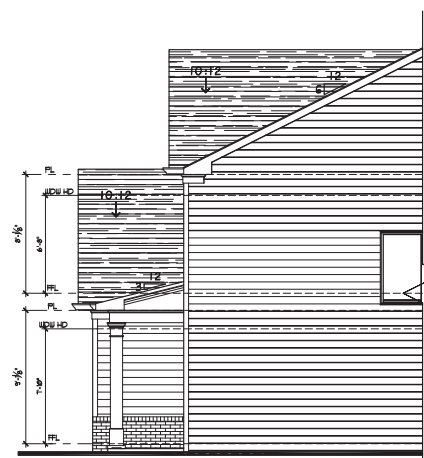

5 Right Side Elevation 'B'
A12 SCALE: 1/4" = 1'-0"

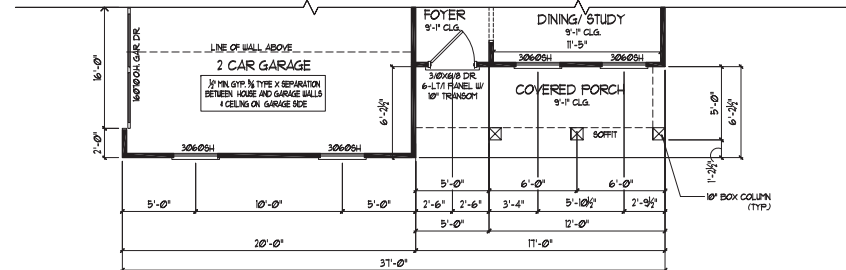

2 1st Floor Plan Elevation 'B'
A12 SCALE: 1/4" = 1'-0"

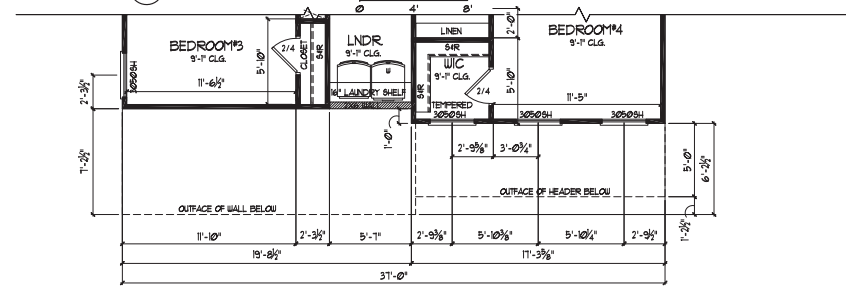

3 2nd Floor Plan Elevation 'B'
A12 SCALE: 1/4" = 1'-0"

Pipton
HOMEBUILDERS

390 BROGDON RD.,
SUWANEE, GA. 30024

DESIGNER HEREBY EXPRESSLY RESERVES HIS COPYRIGHT AND OTHER PROPERTY RIGHT IN THESE PLANS. THESE PLANS AND DRAWINGS ARE NOT TO BE REPRODUCED, CHANGED OR COPIED IN ANY FORM OR MANNER WHATSOEVER WITHOUT FIRST OBTAINING THE EXPRESS WRITTEN PERMISSION AND CONSENT OF THE DESIGNER. NOR ARE THEY TO BE ASSIGNED TO ANY INTEREST WITHOUT FIRST OBTAINING SAID WRITTEN PERMISSION AND CONSENT. DESIGN DRAWING CONTENTS SUBJECT TO ALL APPLICABLE CODES, AND APPROVAL BY A LICENSED ENGINEER AND OR ARCHITECT.

SUB-DIVISION Nunnally Farm
LOT # _____

RELEASED FOR CONSTRUCTION

REVISED

THE PRESTON

JOB NO. NA DRAWN GC
DATE 2/10/2023 CHECKED DB
SCALE: AS NOTED APPROV. DB

FRONT ELEVATION 'B'

APPROVED BY: DAVID BOWEN
DATE _____

SHEET NO.

A12

SHEET: XX OF: XX



390 BROGDON RD.,
SUWANEE, GA. 30024

DESIGNER HEREBY EXPRESSLY RESERVES HIS COPYRIGHT AND OTHER PROPERTY RIGHT IN THESE PLANS. THESE PLANS AND DRAWINGS ARE NOT TO BE REPRODUCED, CHANGED OR COPIED IN ANY FORM OR MANNER WHATSOEVER WITHOUT FIRST OBTAINING THE EXPRESS WRITTEN PERMISSION AND CONSENT OF THE DESIGNER. NOR ARE THEY TO BE ASSIGNED TO ANY INTERESTS WITHOUT FIRST OBTAINING SAID WRITTEN PERMISSION AND CONSENT. DESIGN DRAWING CONTENTS SUBJECT TO ALL APPLICABLE CODES, AND APPROVAL BY A LICENSED ENGINEER AND OR ARCHITECT.

SUB-DIVISION Nunnally Farm
LOT #

RELEASED FOR CONSTRUCTION

REVISED

THE PRESTON

JOB NO.	NA	DRAWN	GC
DATE	2/10/2023	CHECKED	DB
SCALE:	AS NOTED	APPROV.	DB


FRONT ELEVATION 'B'
W/ 3RD CAR GARAGE OPT.

APPROVED BY: DAVID BOWEN
DATE:


SHEET NO.
A1.2.1
SHEET: XX OF: XX




1 Front Elevation 'B' w/ 3rd Car Garage Opt.-Front entry
SCALE: 1/4" = 1'-0"

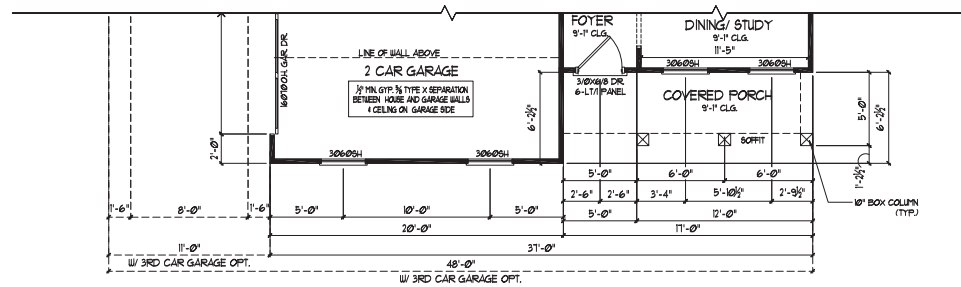

2 1st Floor Plan Elevation 'B'
SCALE: 1/4" = 1'-0"

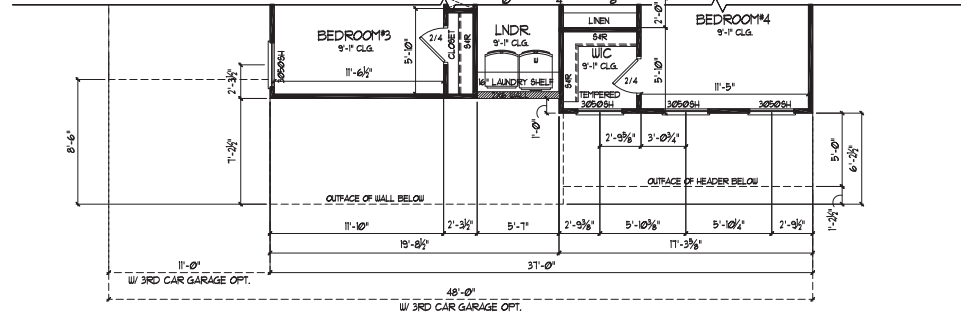


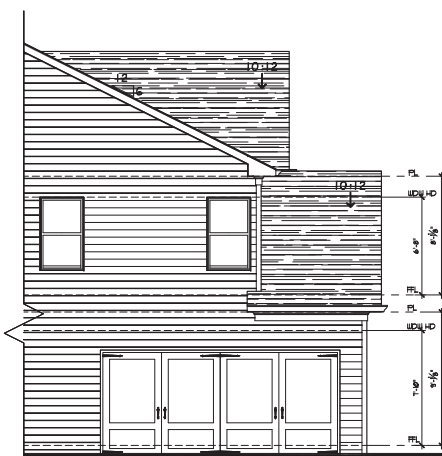


4 Left Side Elevation 'C'
 A1.3 SCALE: 1/4" = 1'-0"




1 Front Elevation 'C'
 A1.3 SCALE: 1/4" = 1'-0"

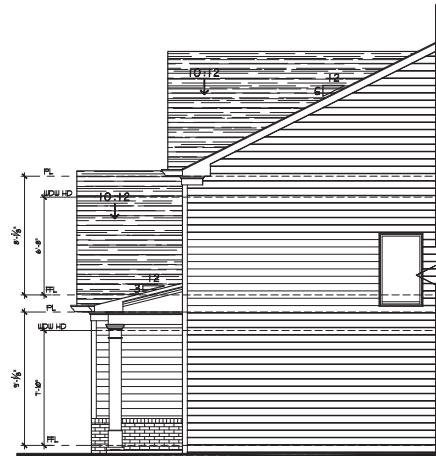

5 Right Side Elevation 'C'
 A1.3 SCALE: 1/4" = 1'-0"

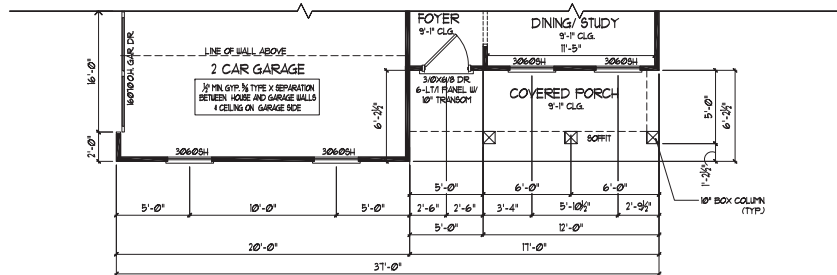

2 1st Floor Plan Elevation 'C'
 A1.3 SCALE: 1/4" = 1'-0"

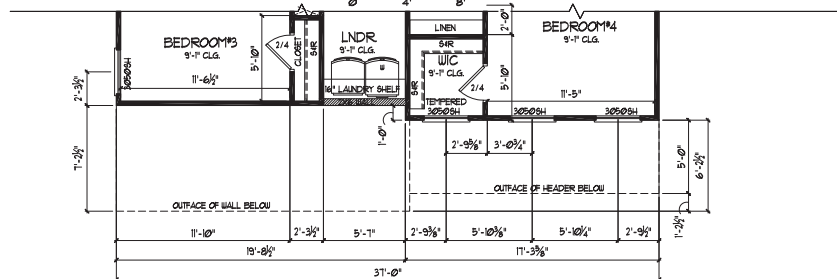

3 2nd Floor Plan Elevation 'C'
 A1.3 SCALE: 1/4" = 1'-0"

Lipton
 HOME BUILDERS

390 BROGDON RD.,
 SUWANEE, GA. 30024

DESIGNER HEREBY EXPRESSLY RESERVES HIS COPYRIGHT AND OTHER PROPERTY RIGHT IN THESE PLANS. THESE PLANS AND DRAWINGS ARE NOT TO BE REPRODUCED, CHANGED OR COPIED IN ANY FORM OR MANNER WHATSOEVER WITHOUT FIRST OBTAINING THE EXPRESS WRITTEN PERMISSION AND CONSENT OF THE DESIGNER. NOR ARE THEY TO BE ASSIGNED TO ANY INTERESTS WITHOUT FIRST OBTAINING SAID WRITTEN PERMISSION AND CONSENT. DESIGN DRAWING CONTENTS SUBJECT TO ALL APPLICABLE CODES, AND APPROVAL BY A LICENSED ENGINEER AND OR ARCHITECT.

SUB-DIVISION Nunnally Farm
 LOT #

RELEASED FOR CONSTRUCTION
REVISED

THE PRESTON

JOB NO.	NA	DRAWN	GC
DATE	2/10/2023	CHECKED	DB
SCALE:	AS NOTED	APROV.	DB

FRONT ELEVATION 'C'

APPROVED BY: DAVID BOWEN
 DATE:

SHEET NO.
A1.3
 SHEET: XX OF XX



390 BROGDON RD.,
SUWANEE, GA. 30024

DESIGNER HEREBY EXPRESSLY RESERVES HIS COPYRIGHT AND OTHER PROPERTY RIGHT IN THESE PLANS. THESE PLANS AND DRAWINGS ARE NOT TO BE REPRODUCED, CHANGED OR COPIED IN ANY FORM OR MANNER WHATSOEVER WITHOUT FIRST OBTAINING THE EXPRESS WRITTEN PERMISSION AND CONSENT OF THE DESIGNER. NOR ARE THEY TO BE ASSIGNED TO ANY INTERESTS WITHOUT FIRST OBTAINING SAID WRITTEN PERMISSION AND CONSENT. DESIGN DRAWING CONTENTS SUBJECT TO ALL APPLICABLE CODES, AND APPROVAL BY A LICENSED ENGINEER AND OR ARCHITECT.

SUB-DIVISION Nunnally Farm
LOT # _____

RELEASED FOR CONSTRUCTION

REVISED

THE PRESTON

JOB NO.	NA	DRAWN	GC
DATE	2/10/2023	CHECKED	DB
SCALE:	AS NOTED	APPROV.	DB

FRONT ELEVATION 'C'
W/ 3RD CAR GARAGE OPT.

APPROVED BY: DAVID BOWEN

DATE: _____


SHEET NO.

A13.1


SHEET: XX OF: XX



1 Front Elevation 'C' w/ 3rd Car Garage Opt.-Front entry
A13.1 SCALE: 1/4" = 1'-0"

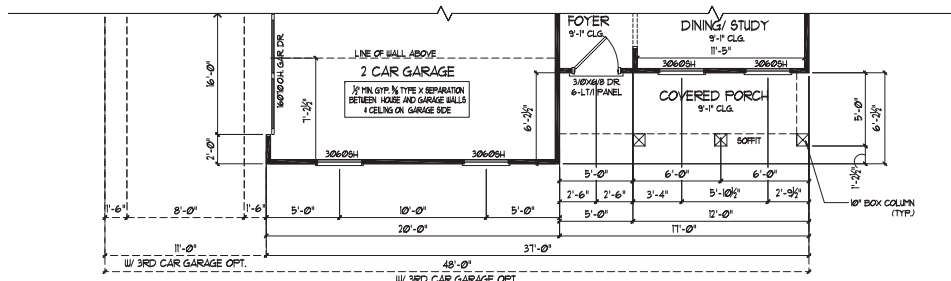

2 1st Floor Plan Elevation 'C'
A13.1 SCALE: 1/4" = 1'-0"

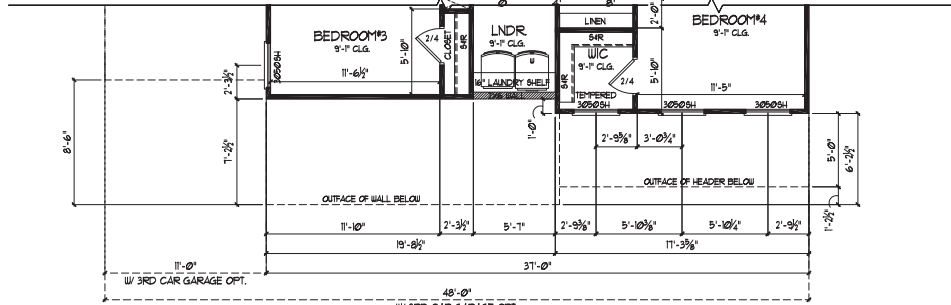

3 2nd Floor Plan Elevation 'C'
A13.1 SCALE: 1/4" = 1'-0"



1 Left Side Elevation
 A2.1 SCALE: 1/4" = 1'-0"
 0 4' 8'

2 Right Side Elevation
 A2.1 SCALE: 1/4" = 1'-0"
 0 4' 8'



3 Rear Elevation - Standard
 A2.1 SCALE: 1/4" = 1'-0"
 0 4' 8'



4 Rear Elevation w/ Opt. Covered Porch
 A2.2 SCALE: 1/4" = 1'-0"
 0 4' 8'



390 BROGDON RD.,
 SUWANEE, GA. 30024

DESIGNER HEREBY EXPRESSLY RESERVES HIS COPYRIGHT AND OTHER PROPERTY RIGHT IN THESE PLANS. THESE PLANS AND DRAWINGS ARE NOT TO BE REPRODUCED, CHANGED OR COPIED IN ANY FORM OR MANNER WHATSOEVER WITHOUT FIRST OBTAINING THE EXPRESS WRITTEN PERMISSION AND CONSENT OF THE DESIGNER. NOR ARE THEY TO BE ASSIGNED TO ANY INTERESTS WITHOUT FIRST OBTAINING SAID WRITTEN PERMISSION AND CONSENT. DESIGN DRAWING CONTENTS SUBJECT TO ALL APPLICABLE CODES, AND APPROVAL BY A LICENSED ENGINEER AND OR ARCHITECT.

SUB-DIVISION *Fench Manor*
 LOT #

RELEASED FOR CONSTRUCTION

REVISED	

THE PRESTON

JOB NO.	NA	DRAWN	GC
DATE	2/10/2023	CHECKED	DB
SCALE:	AS NOTED	APPROV.	DB


SIDE & REAR ELEVATIONS 'A' & 'B'

APPROVED BY: DAVID BOWEN
 DATE:

SHEET NO.
 A2.1
 SHEET: XX OF: XX



2 Rear Elevation w/ 3rd Car Garage Option
 A22 SCALE: 1/4" = 1'-0"

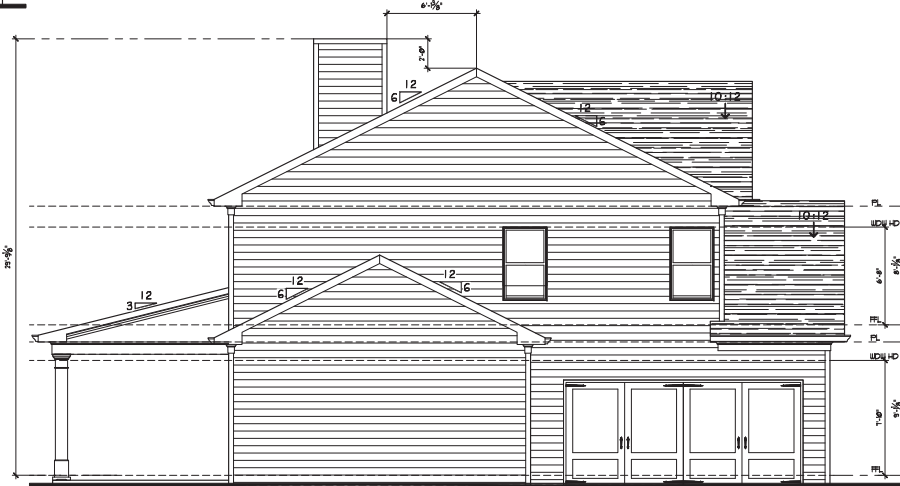

1 Left Side Elevation w/ 3rd Car Garage Option
 A22 SCALE: 1/4" = 1'-0"



3 Rear Elev. w/ 3rd Car Garage & Covered Porch Opt.
 A23 SCALE: 1/4" = 1'-0"



390 BROGDON RD.,
 SUWANEE, GA. 30024

DESIGNER HEREBY EXPRESSLY RESERVES HIS COPYRIGHT AND OTHER PROPERTY RIGHT IN THESE PLANS. THESE PLANS AND DRAWINGS ARE NOT TO BE REPRODUCED, CHANGED OR COPIED IN ANY FORM OR MANNER WHATSOEVER WITHOUT FIRST OBTAINING THE EXPRESS WRITTEN PERMISSION AND CONSENT OF THE DESIGNER. NOR ARE THEY TO BE ASSIGNED TO ANY INTERESTS WITHOUT FIRST OBTAINING SAID WRITTEN PERMISSION AND CONSENT. DESIGN DRAWING CONTENTS SUBJECT TO ALL APPLICABLE CODES, AND APPROVAL BY A LICENSED ENGINEER AND OR ARCHITECT.

SUB-DIVISION Nunnally Farm
 LOT #

RELEASED FOR CONSTRUCTION

REVISED

THE PRESTON

JOB NO.	NA	DRAWN	GC
DATE	2/10/2023	CHECKED	DB
SCALE:	AS NOTED	APPROV.	DB


SIDE & REAR ELEVATIONS 'C' & 'D'

APPROVED BY: DAVID BOWEN
 DATE:


SHEET NO.

A2.2


SHEET: XX OF XX

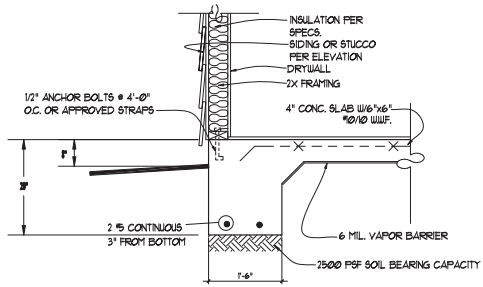


2 TURNDOWN SLAB SECTION W/O BRICK VENEER
SCALE: NTS

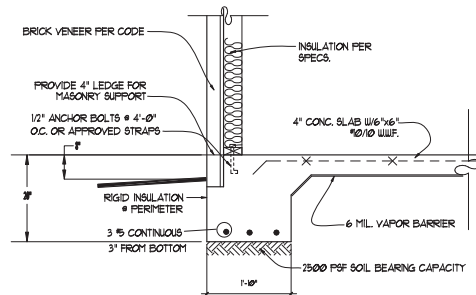


3 TURNDOWN SLAB SECTION W/ BRICK VENEER
SCALE: NTS

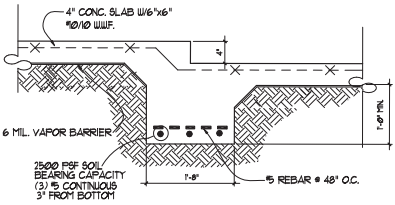


4 STEPPED SLAB SECTION
SCALE: NTS

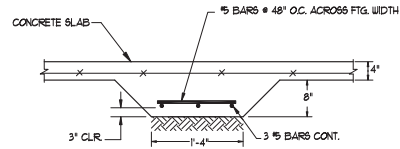

5 INTERIOR GRADE BEAM
SCALE: NTS

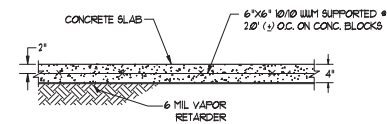

6 TYPICAL SLAB ON GRADE
SCALE: NTS

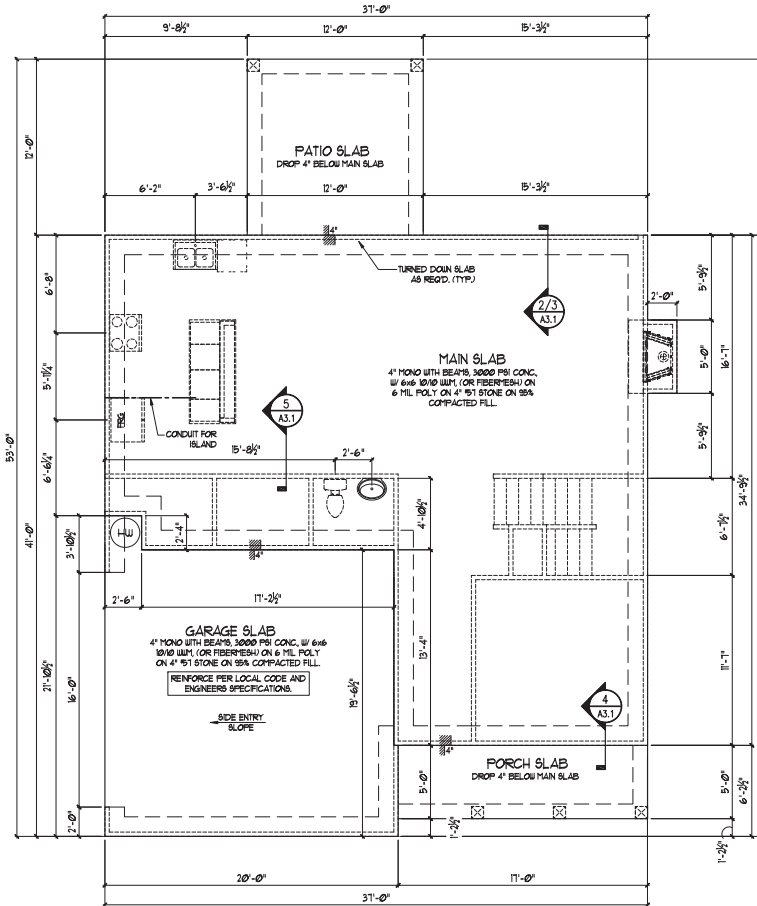

1 Slab Foundation Plan
SCALE: 1/4\"/>

NOTE:
VERIFY W/ FLOOR TRUSS
PROVIDER ANY
LOCATIONS FOR
THICKENED SLABS
PRIOR TO PLACEMENT
OF CONCRETE SLAB.

VERIFY ALL GRADE BEAM
LOCATIONS PRIOR TO
POURING OF CONCRETE.

NOTE: LOCATE GRADE
BEAMS UNDER ALL LOAD
BEARING WALLS.



390 BROGDON RD.,
SUWANEE, GA. 30024

DESIGNER HEREBY EXPRESSLY RESERVES HIS COPYRIGHT
AND OTHER PROPERTY RIGHT IN THESE PLANS. THESE
PLANS AND DRAWINGS ARE NOT TO BE REPRODUCED,
CHANGED OR COPIED IN ANY FORM OR MANNER
WHATSOEVER WITHOUT FIRST OBTAINING THE EXPRESS
WRITTEN PERMISSION AND CONSENT OF THE DESIGNER. NOR
ARE THEY TO BE ASSIGNED TO ANY INTERESTS WITHOUT FIRST
OBTAINING SAID WRITTEN PERMISSION AND CONSENT. DESIGN
DRAWING CONTENTS SUBJECT TO ALL APPLICABLE CODES,
AND APPROVAL BY A LICENSED ENGINEER AND/OR
A R C H I T E C T.

SUB-DIVISION Nunnally Farm
LOT #

RELEASED FOR CONSTRUCTION

REVISED

THE PRESTON

JOB NO.	NA	DRAWN	GC
DATE	2/10/2023	CHECKED	DB
SCALE:	AS NOTED	APPROV.	DB

SLAB FOUNDATION PLAN

APPROVED BY: DAVID BOWEN

DATE:

SHEET NO.

A3.1

SHEET: XX OF XX



390 BROGDON RD.,
SUWANEE, GA. 30024

DESIGNER HEREBY EXPRESSLY RESERVES HIS COPYRIGHT AND OTHER PROPERTY RIGHT IN THESE PLANS. THESE PLANS AND DRAWINGS ARE NOT TO BE REPRODUCED, CHANGED OR COPIED IN ANY FORM OR MANNER WHATSOEVER WITHOUT FIRST OBTAINING THE EXPRESS WRITTEN PERMISSION AND CONSENT OF THE DESIGNER. NOR ARE THEY TO BE ASSIGNED TO ANY INTERESTS WITHOUT FIRST OBTAINING SAID WRITTEN PERMISSION AND CONSENT. DESIGN DRAWING CONTENTS SUBJECT TO ALL APPLICABLE CODES, AND APPROVAL BY A LICENSED ENGINEER AND OR ARCHITECT.

SUB-DIVISION Nunnally Farm
LOT #

RELEASED FOR CONSTRUCTION

REVISED	


THE PRESTON

JOB NO.	NA	DRAWN	GC
DATE	2/10/2023	CHECKED	DB
SCALE:	AS NOTED	APPROV.	DB

SLAB FOUNDATION PLAN
W/ 3RD CAR GARAGE OPT.

APPROVED BY: DAVID BOWEN
DATE:



SHEET NO.
A3.2
SHEET: XX OF XX

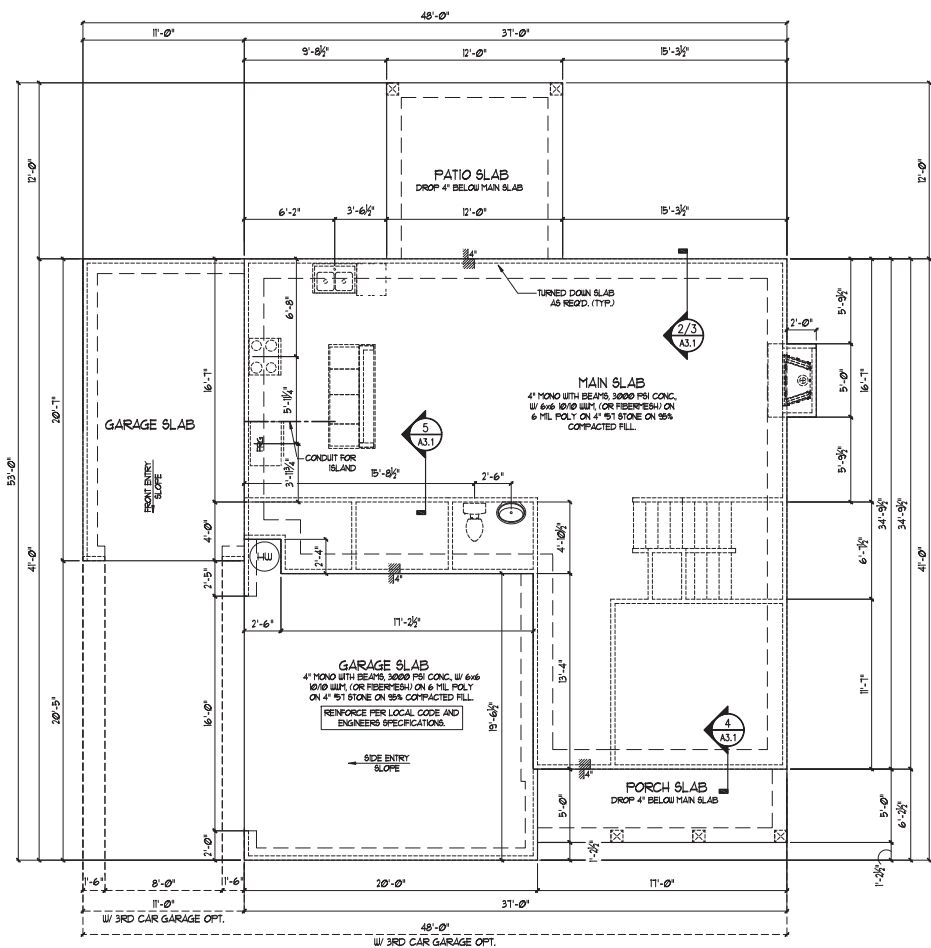


NOTE:
VERIFY W/ FLOOR TRUSS PROVIDER ANY LOCATIONS FOR THICKENED SLABS PRIOR TO PLACEMENT OF CONCRETE SLAB.

VERIFY ALL GRADE BEAM LOCATIONS PRIOR TO POURING OF CONCRETE.


NOTE: LOCATE GRADE BEAMS UNDER ALL LOAD BEARING WALLS

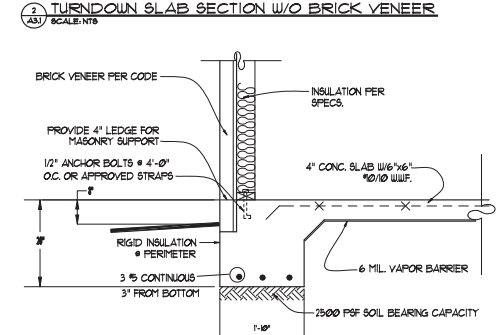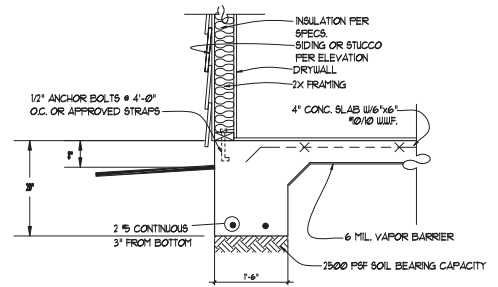


3 TURNDOWN SLAB SECTION W/ BRICK VENEER
SCALE: NTS

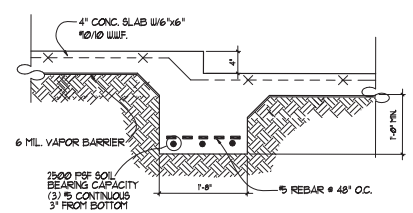


4 STEPPED SLAB SECTION
SCALE: NTS

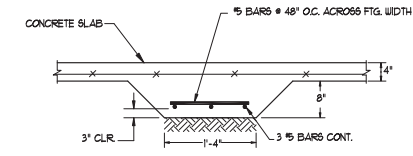

5 INTERIOR GRADE BEAM
SCALE: NTS

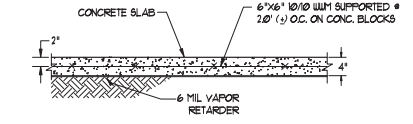

6 TYPICAL SLAB ON GRADE
SCALE: NTS

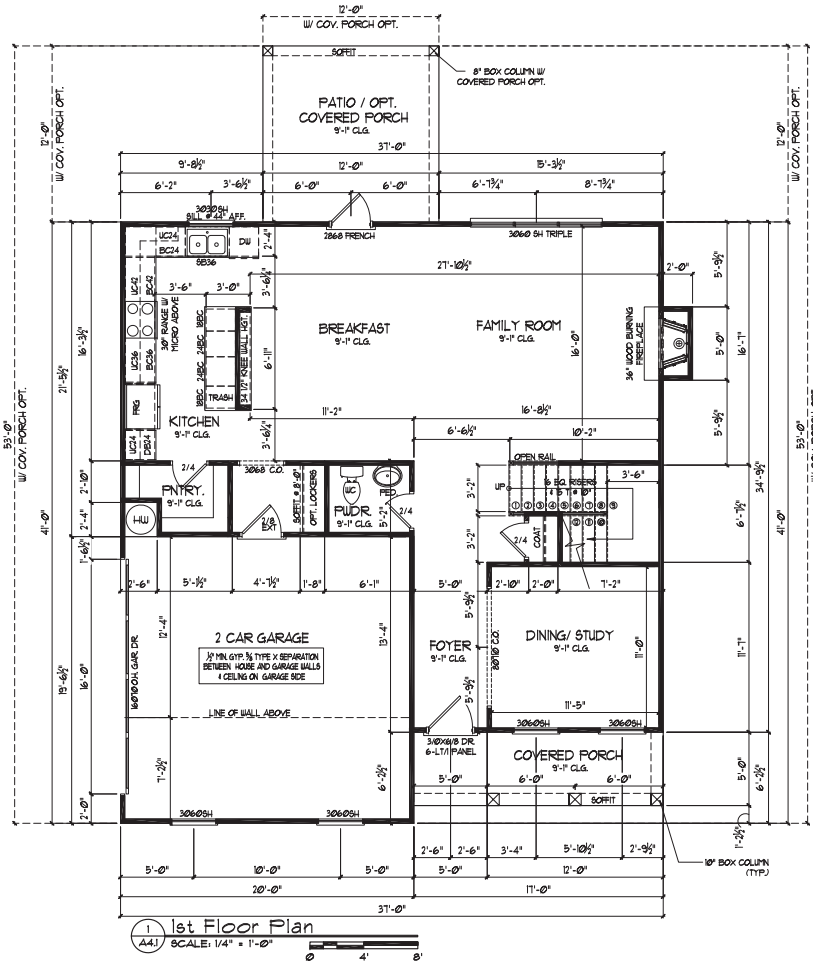

1st Floor Plan
 SCALE: 1/4" = 1'-0"
 0 4' 8'

SQUARE FOOTAGE:	
MAIN LEVEL	1203
OPT. BONUS ROOM	1203
TOTAL HEATED	2206
2 CAR GARAGE	393
FRONT PORCH	85
TOTAL FRAMED	2306
OPT. COVERED PORCH	144
OPT. 3RD CAR GARAGE	226

Tipton
 HOME BUILDERS

390 BROGDON RD.,
 SUWANEE, GA. 30024

DESIGNER HEREBY EXPRESSLY RESERVES HIS COPYRIGHT AND OTHER PROPERTY RIGHT IN THESE PLANS. THESE PLANS AND DRAWINGS ARE NOT TO BE REPRODUCED, CHANGED OR COPIED IN ANY FORM OR MANNER WHATSOEVER WITHOUT FIRST OBTAINING THE EXPRESS WRITTEN PERMISSION AND CONSENT OF THE DESIGNER. NOR ARE THEY TO BE ASSIGNED TO ANY INTERESTS WITHOUT FIRST OBTAINING SAID WRITTEN PERMISSION AND CONSENT. DESIGN DRAWING CONTENTS SUBJECT TO ALL APPLICABLE CODES, AND APPROVAL BY A LICENSED ENGINEER AND OR ARCHITECT.

SUB-DIVISION Nunnally Farm
 LOT # _____

RELEASED FOR CONSTRUCTION

REVISED


THE PRESTON

JOB NO. NA DRAWN GC
 DATE 2/10/2023 CHECKED DB
 SCALE: AS NOTED APPROV. DB

MAIN FLOOR PLAN

APPROVED BY: DAVID BOWEN
 DATE: _____

SHEET NO.
A4.1
 SHEET: XX OF XX

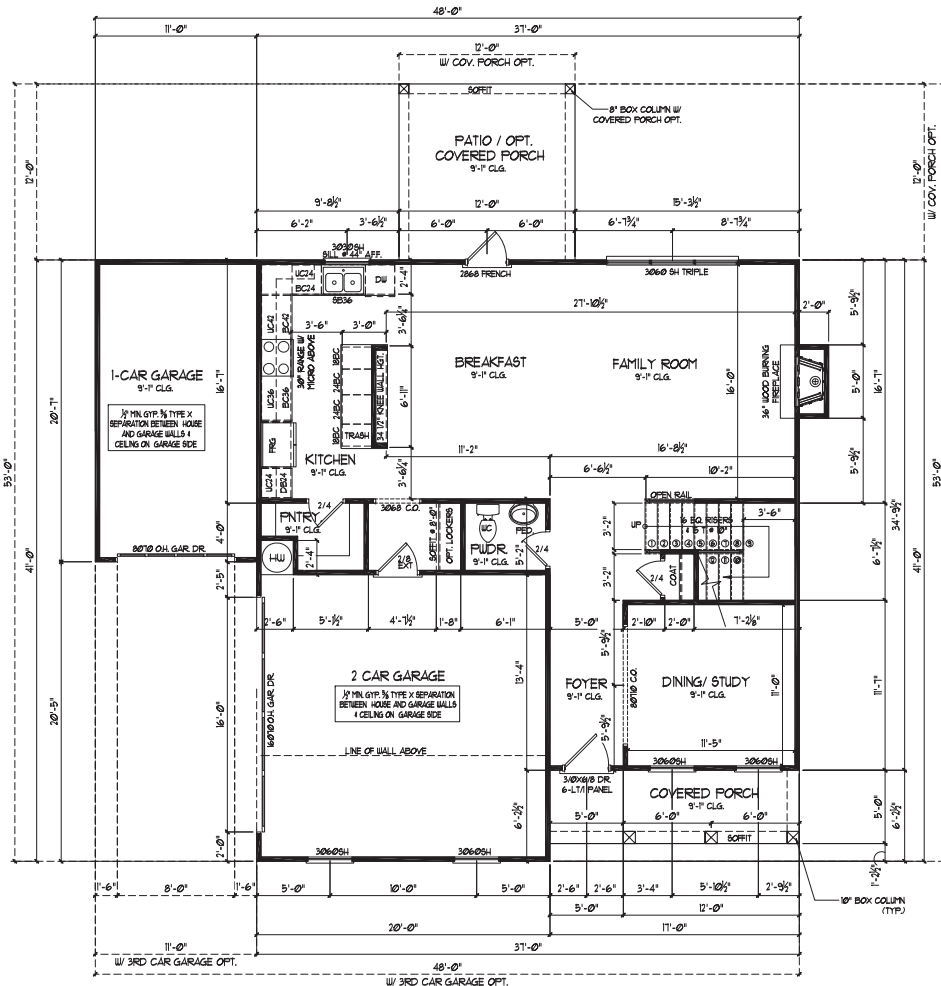

SQUARE FOOTAGE:	
MAIN LEVEL	1203
OPT. BONUS ROOM	1203
TOTAL HEATED	2228
1 CAR GARAGE	393
FRONT PORCH	85
TOTAL FRAMED	2306
OPT. COVERED PORCH	144
OPT. 3RD CAR GARAGE	226

1st Floor Plan w/ 3rd Car Garage Opt.-Front entry
 SCALE: 1/4" = 1'-0"

Lipton
 HOME BUILDERS

390 BROGDON RD.,
 SUWANEE, GA. 30024

DESIGNER HEREBY EXPRESSLY RESERVES HIS COPYRIGHT AND OTHER PROPERTY RIGHT IN THESE PLANS. THESE PLANS AND DRAWINGS ARE NOT TO BE REPRODUCED, CHANGED OR COPIED IN ANY FORM OR MANNER WHATSOEVER WITHOUT FIRST OBTAINING THE EXPRESS WRITTEN PERMISSION AND CONSENT OF THE DESIGNER. NOR ARE THEY TO BE ASSIGNED TO ANY INTERESTS WITHOUT FIRST OBTAINING SAID WRITTEN PERMISSION AND CONSENT. DESIGN DRAWING CONTENTS SUBJECT TO ALL APPLICABLE CODES, AND APPROVAL BY A LICENSED ENGINEER AND OR ARCHITECT.

SUB-DIVISION Nunnally Farm
 LOT # _____

RELEASED FOR CONSTRUCTION

REVISED

THE PRESTON

JOB NO. NA DRAWN GC
 DATE 2/10/2023 CHECKED DB
 SCALE: AS NOTED APPROV. DB

MAIN FLOOR PLAN
 W/ 3RD CAR GARAGE OPT.

APPROVED BY: DAVID BOWEN
 DATE: _____

SHEET NO.
A4.2
 SHEET: XX OF XX



390 BROGDON RD.,
SUWANEE, GA. 30024

DESIGNER HEREBY EXPRESSLY RESERVES HIS COPYRIGHT AND OTHER PROPERTY RIGHT IN THESE PLANS. THESE PLANS AND DRAWINGS ARE NOT TO BE REPRODUCED, CHANGED OR COPIED IN ANY FORM OR MANNER WHATSOEVER WITHOUT FIRST OBTAINING THE EXPRESS WRITTEN PERMISSION AND CONSENT OF THE DESIGNER. NOR ARE THEY TO BE ASSIGNED TO ANY INTERESTS WITHOUT FIRST OBTAINING SAID WRITTEN PERMISSION AND CONSENT. DESIGN DRAWING CONTENTS SUBJECT TO ALL APPLICABLE CODES, AND APPROVAL BY A LICENSED ENGINEER AND OR ARCHITECT.

SUB-DIVISION Nunnally Farm
LOT # _____

RELEASED FOR CONSTRUCTION

REVISED

THE PRESTON

JOB NO. NA DRAWN GC
DATE 2/10/2023 CHECKED DB
SCALE: AS NOTED APPROV. DB

UPPER LEVEL FLOOR PLAN


APPROVED BY: DAVID BOWEN

DATE: _____

SHEET NO.

A5.1

SHEET: XX OF XX

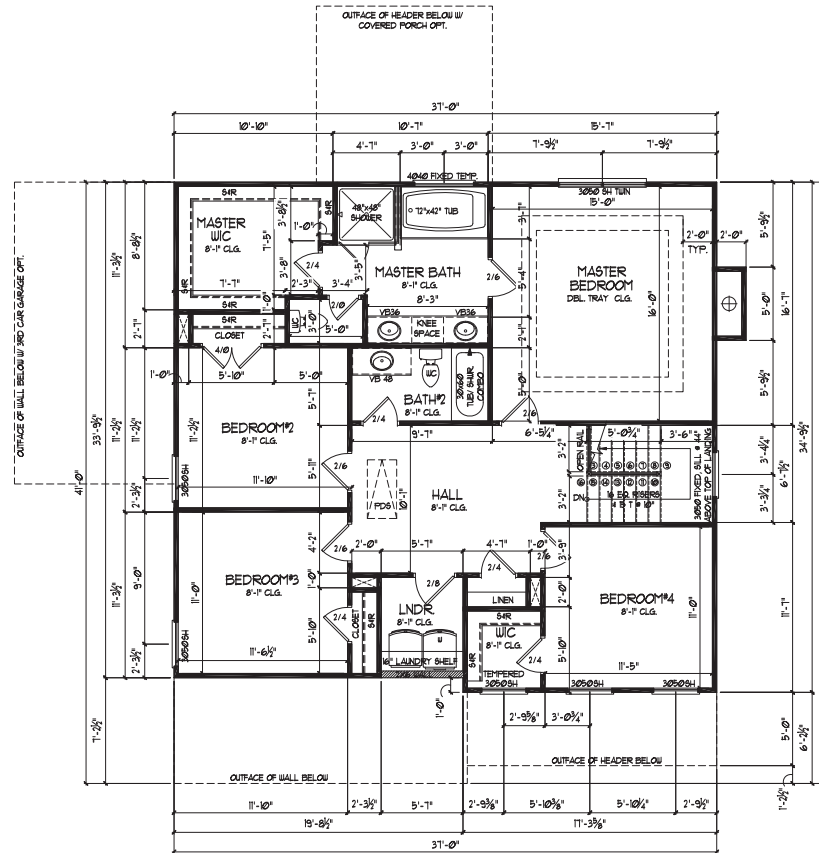

1 2nd Floor Plan

SCALE: 1/4" = 1'-0"



SQUARE FOOTAGE:	
MAIN LEVEL	1093
OPT. BONUS ROOM	1429
TOTAL HEATED	2728
1 CAR GARAGE	393
FRONT PORCH	89
TOTAL FRA'ED	2706
OPT. COVERED PORCH	144
OPT. 3RD CAR GARAGE	276



390 BROGDON RD.,
SUWANEE, GA. 30024

DESIGNER HEREBY EXPRESSLY RESERVES HIS COPYRIGHT AND OTHER PROPERTY RIGHT IN THESE PLANS. THESE PLANS AND DRAWINGS ARE NOT TO BE REPRODUCED, CHANGED OR COPIED IN ANY FORM OR MANNER WHATSOEVER WITHOUT FIRST OBTAINING THE EXPRESS WRITTEN PERMISSION AND CONSENT OF THE DESIGNER. NOR ARE THEY TO BE ASSIGNED TO ANY INTERESTS WITHOUT FIRST OBTAINING SAID WRITTEN PERMISSION AND CONSENT. DESIGN DRAWING CONTENTS SUBJECT TO ALL APPLICABLE CODES, AND APPROVAL BY A LICENSED ENGINEER AND OR ARCHITECT.

SUB-DIVISION Nunnally Farm
LOT #

RELEASED FOR CONSTRUCTION

REVISED

THE PRESTON

JOB NO.	NA	DRAWN	GC
DATE	2/10/2023	CHECKED	DB
SCALE:	AS NOTED	APPROV.	DB


ROOF PLANS

APPROVED BY: DAVID BOWEN
DATE:


SHEET NO.

A6.1



SHEET: XX OF XX

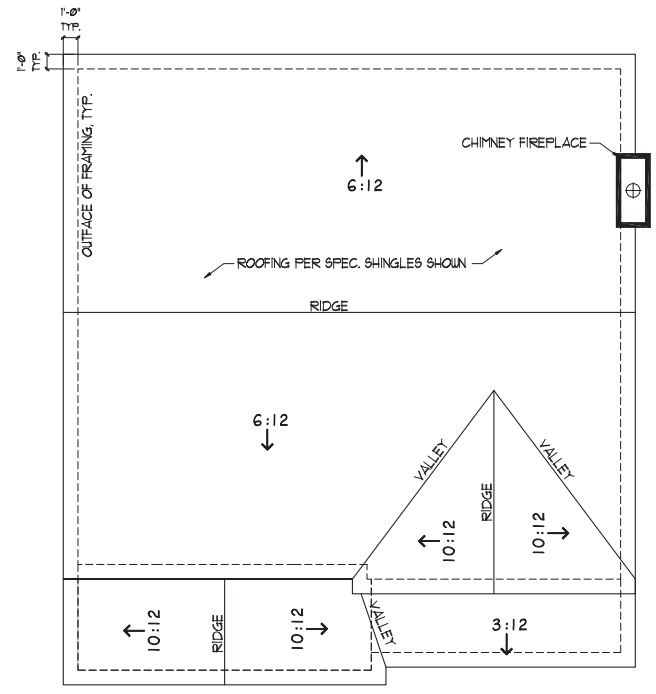

1 Roof Plan Elevation
SCALE: 1/4" = 1'-0"

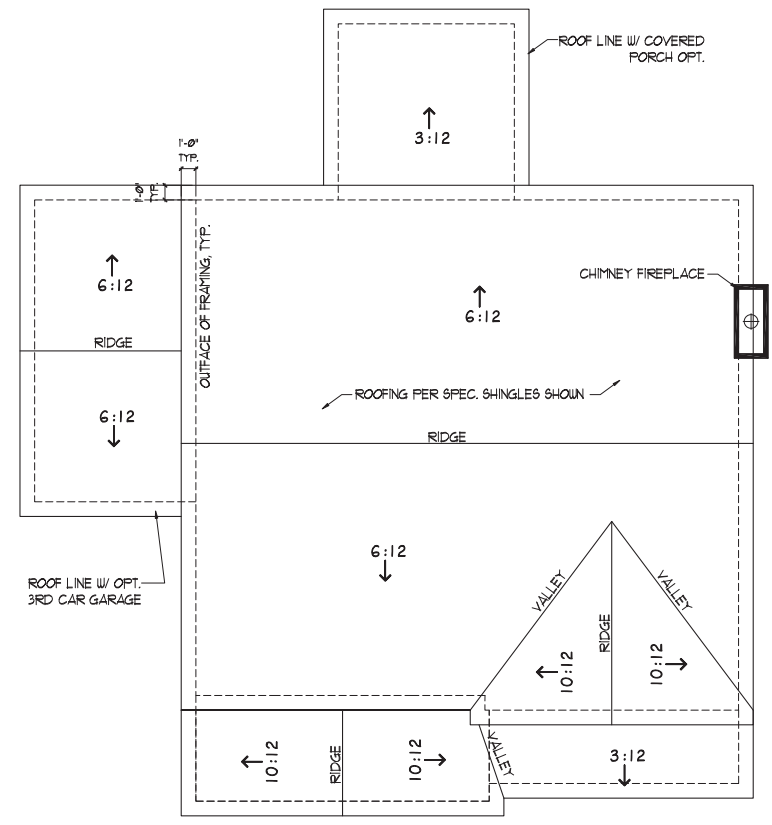

2 Roof Plan w/ options
SCALE: 1/4" = 1'-0"

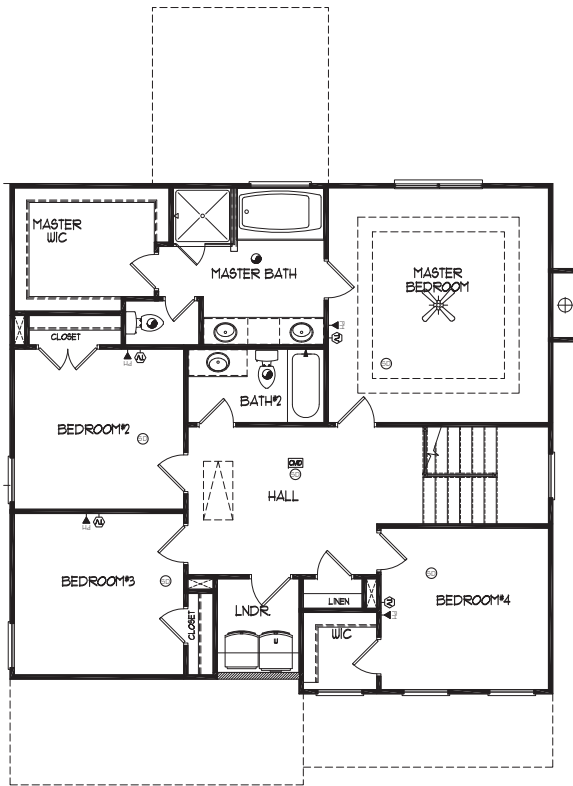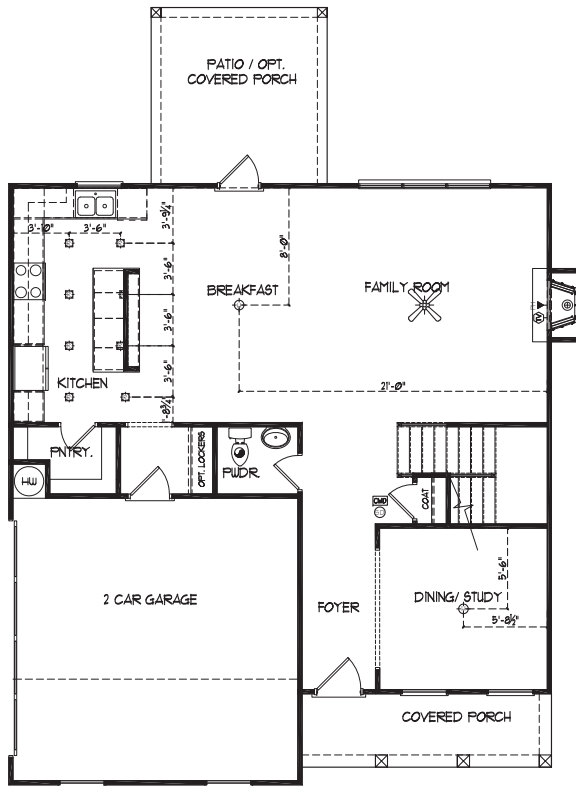

ELECTRICAL LEGEND			
—GAS	Gas Line	☐	Recessed Can Light
—CW	Cold Water	⊙	Eyeball Light
—	Electrical Panel	⊕	Wall Mounted Light
—	Electrical Meter	⊖	Wall Sconce
—	Disconnect Switch	— —	Fluorescent Light w/1 Bulb
—	Switch	— — —	Fluorescent Light w/2 Bulbs
—	3-Way Switch	⊞	Vapor Protected Light
—	4-Way Switch	⊟	Exhaust Fan
—	Dimmer Switch	⊠	Exhaust Fan w/Light
—	Button	⊡	Exhaust Fan w/Heat & Light
—	Duplex Outlet	⊞	Smoke Detector
—	Quadplex Outlet	⊞	Carbon Monoxide Detector
—	Switched Duplex Outlet	⊞	Thermostat
FLOOR	Floor Outlet	⊞	Direct Wire
GFI	GFI Outlet	⊞	Phone Jack
WP-GFI	Water Proof GFI Outlet	⊞	Media Jack
C/C	Ceiling Mounted Outlet	⊞	Cable TV Outlet
220V	220V Outlet	⊞	Door Chimes
⊞	Ceiling Mounted Light	⊞	Security Panel
⊞	Hanging Ceiling Mounted Light	⊞	Flood Light
⊞	Ceiling Fan	⊞	Ceiling Fan w/Light

Lipton
HOMEBUILDERS

390 BROGDON RD.,
SUWANEE, GA. 30024

DESIGNER HEREBY EXPRESSLY RESERVES HIS COPYRIGHT AND OTHER PROPERTY RIGHT IN THESE PLANS. THESE PLANS AND DRAWINGS ARE NOT TO BE REPRODUCED, CHANGED OR COPIED IN ANY FORM OR MANNER WHATSOEVER WITHOUT FIRST OBTAINING THE EXPRESS WRITTEN PERMISSION AND CONSENT OF THE DESIGNER. NOR ARE THEY TO BE ASSIGNED TO ANY INTERESTS WITHOUT FIRST OBTAINING SAID WRITTEN PERMISSION AND CONSENT. DESIGN DRAWING CONTENTS SUBJECT TO ALL APPLICABLE CODES, AND APPROVAL BY A LICENSED ENGINEER AND OR ARCHITECT.

SUB-DIVISION Nunnally Farm
LOT #

RELEASED FOR CONSTRUCTION

REVISED

THE PRESTON

JOB NO.	NA	DRAWN	GC
DATE	2/10/2023	CHECKED	DB
SCALE:	AS NOTED	APPROV.	DB

ELECTRICAL PLANS

APPROVED BY: DAVID BOWEN
DATE:

SHEET NO.
A7.1
SHEET: XX OF: XX

THE MAPLEWOOD

(Nunnally Farm Rd.)



390 BROGDON RD.,
SUWANEE, GA. 30024

DESIGNER HEREBY EXPRESSLY RESERVES HIS COPYRIGHT AND OTHER PROPERTY RIGHT IN THESE PLANS. THESE PLANS AND DRAWINGS ARE NOT TO BE REPRODUCED, CHANGED OR COPIED IN ANY FORM OR MANNER WHATSOEVER WITHOUT FIRST OBTAINING THE EXPRESS WRITTEN PERMISSION AND CONSENT OF THE DESIGNER. NOR ARE THEY TO BE ASSIGNED TO ANY INTERESTS WITHOUT FIRST OBTAINING SAID WRITTEN PERMISSION AND CONSENT. DESIGN DRAWING CONTENTS SUBJECT TO ALL APPLICABLE CODES, AND APPROVAL BY A LICENSED ENGINEER AND OR ARCHITECT.

SUB-DIVISION Nunnally Farm
LOT # _____

RELEASED FOR CONSTRUCTION

REVISED

THE MAPLEWOOD

JOB NO. NA DRAWN GC
DATE 2/15/2023 CHECKED DB
SCALE: AS NOTED APPROV. DB

COVER SHEET

APPROVED BY: DAVID BOWEN
DATE: _____

SHEET NO.

C0.0

SHEET: XX OF XX



ELEVATION A



ELEVATION B



ELEVATION C



ELEVATION D

BUILDING CODE ANALYSIS

USE GROUP: SINGLE FAMILY DWELLING
CONSTRUCTION CLASS: UNPROTECTED
HEIGHT & AREA LIMITATION: 2 STORY MAXIMUM HGT. 35 FT.
EMERGENCY ESCAPE: EGRESS OR RESCUE WINDOWS FROM SLEEPING ROOMS SHALL HAVE A MINIMUM OF 5.7 SQ. FT.

GARAGE/HOUSE CEILING/HOUSE ASSEMBLY: 1/2" GYPSUM BD. WALL & CEILING W/ 20 MINUTE GARAGE/HOUSE DOOR

DESIGN LOADS:
LIVE LOAD: SLEEPING = 30 PSF
NON-SLEEPING = 40 PSF
DECKS = 40 PSF
DEAD LOAD = 10 PSF
BASIC WIND SPEED = 80 MPH
STAIR LIVE LOAD = 40 PSF
ROOF LIVE LOAD = 20 PSF
LATERAL SOIL PRESSURE = 30 PCF (ASSUMED)


ATTIC VENTILATION: (EXAMPLE)
2398 SF. / 300 = 7.99 SF. FREE AREA REQ'D
RIDGE VENT = 39 LF. X Ø89 FREE AREA/LF = 3.31 SF. PROVIDED
SOFFIT VENT = 54 LF. X Ø49 FREE AREA/LF = 2.43 SF. PROVIDED

NOTE: VERIFY ALL APPLICABLE BUILDING CODES WITH STATE AND LOCAL JURISDICTION PRIOR TO CONSTRUCTION.

DRAWING INDEX

- C0.0 COVER SHEET
- A11 ELEVATION "A"
- A12 ELEVATION "B"
- A13 ELEVATION "C"
- A14 ELEVATION "D"
- A21 SIDES & REAR ELEVATIONS 'A' & 'B'
- A22 SIDES & REAR ELEVATIONS 'C' & 'D'
- A31 SLAB PLAN
- A41 MAIN FLOOR PLAN
- A51 ROOF PLANS
- A6.1 ELECTRICAL PLAN

FOOTPRINT

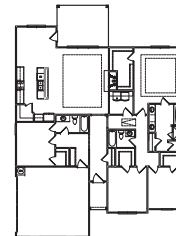

AREA CALCULATION

49'-6" x 61'

SQUARE FOOTAGE:	
MAIN LEVEL	2108
TOTAL HEATED	2108
1 CAR GARAGE	457
FRONT PORCH	40
TOTAL FRAMED	2580
OPT. REAR COVERED PORCH	96



390 BROGDON RD.,
SUWANEE, GA. 30024

DESIGNER HEREBY EXPRESSLY RESERVES HIS COPYRIGHT AND OTHER PROPERTY RIGHT IN THESE PLANS. THESE PLANS AND DRAWINGS ARE NOT TO BE REPRODUCED, CHANGED OR COPIED IN ANY FORM OR MANNER WHATSOEVER WITHOUT FIRST OBTAINING THE EXPRESS WRITTEN PERMISSION AND CONSENT OF THE DESIGNER. NOR ARE THEY TO BE ASSIGNED TO ANY INTERESTS WITHOUT FIRST OBTAINING SAID WRITTEN PERMISSION AND CONSENT. DESIGN DRAWING CONTENTS SUBJECT TO ALL APPLICABLE CODES, AND APPROVAL BY A LICENSED ENGINEER AND OR ARCHITECT.

SUB-DIVISION *Nunnally Farm*
LOT #

RELEASED FOR CONSTRUCTION

REVISED


THE MAPLEWOOD

JOB NO.	NA	DRAWN	GC
DATE	2/15/2023	CHECKED	DB
SCALE:	AS NOTED	APPROV.	DB


FRONT ELEVATION 'A'

APPROVED BY: DAVID BOWEN
DATE:


SHEET NO.
A1.1
SHEET: XX OF: XX

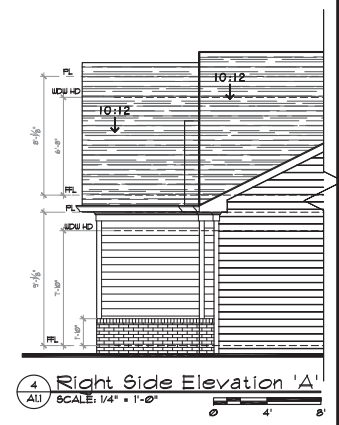


4 Right Side Elevation 'A'
ALL SCALE: 1/4" = 1'-0"

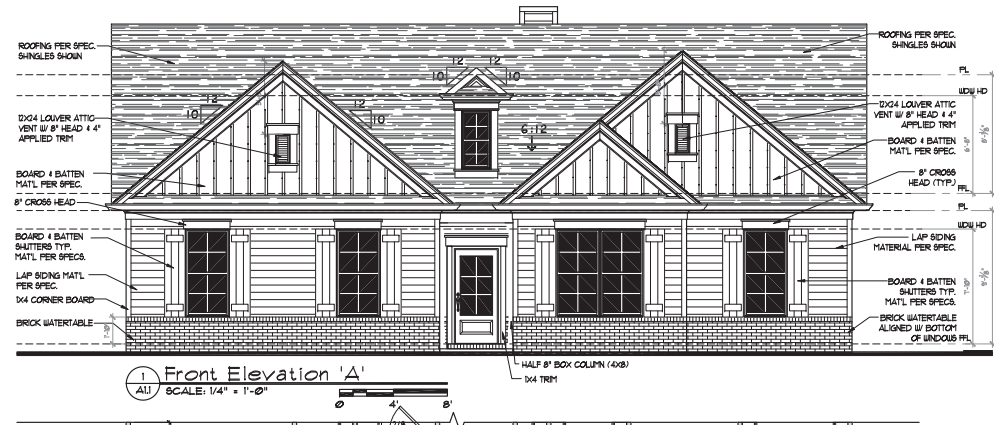

1 Front Elevation 'A'
ALL SCALE: 1/4" = 1'-0"

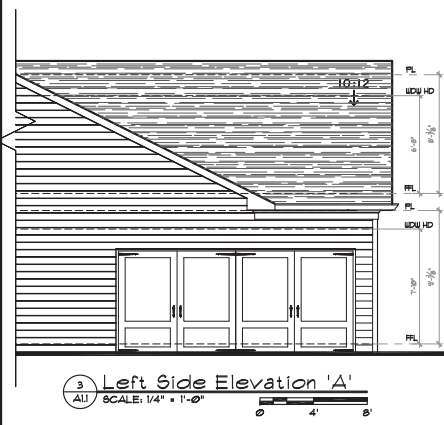

3 Left Side Elevation 'A'
ALL SCALE: 1/4" = 1'-0"

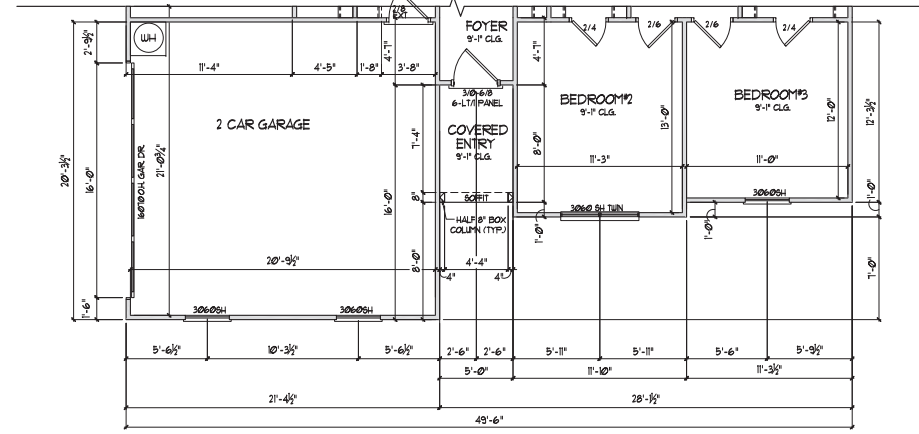

2 1st Floor Plan Elevation 'A'
ALL SCALE: 1/4" = 1'-0"



390 BROGDON RD.,
SUWANEE, GA. 30024

DESIGNER HEREBY EXPRESSLY RESERVES HIS COPYRIGHT AND OTHER PROPERTY RIGHT IN THESE PLANS. THESE PLANS AND DRAWINGS ARE NOT TO BE REPRODUCED, CHANGED OR COPIED IN ANY FORM OR MANNER WHATSOEVER WITHOUT FIRST OBTAINING THE EXPRESS WRITTEN PERMISSION AND CONSENT OF THE DESIGNER. NOR ARE THEY TO BE ASSIGNED TO ANY INTERESTS WITHOUT FIRST OBTAINING SAID WRITTEN PERMISSION AND CONSENT. DESIGN DRAWING CONTENTS SUBJECT TO ALL APPLICABLE CODES, AND APPROVAL BY A LICENSED ENGINEER AND OR ARCHITECT.

SUB-DIVISION Nunnally Farm
LOT # _____

RELEASED FOR CONSTRUCTION

REVISED


THE MAPLEWOOD

JOB NO.	NA	DRAWN	GC
DATE	2/15/2023	CHECKED	DB
SCALE:	AS NOTED	APPROV.	DB

FRONT ELEVATION 'B'

APPROVED BY: DAVID BOWEN
DATE _____


SHEET NO.
A1.2
SHEET: XX OF: XX

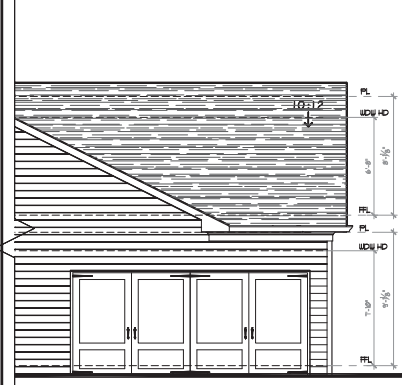


3 Left Side Elevation 'B'
A1.2 SCALE: 1/4" = 1'-0"



1 Front Elevation 'B'
A1.2 SCALE: 1/4" = 1'-0"

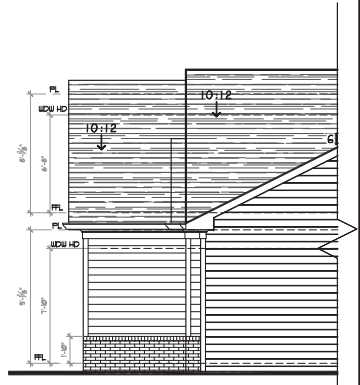

4 Right Side Elevation 'B'
A1.2 SCALE: 1/4" = 1'-0"

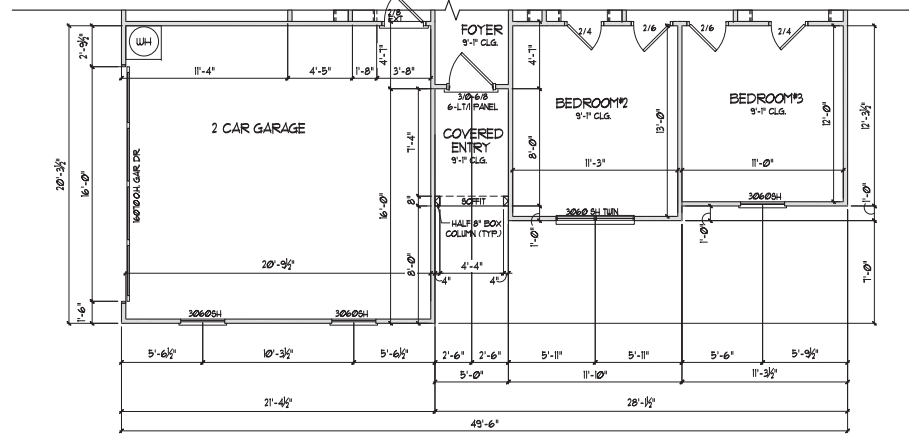

2 1st Floor Plan Elevation 'B'
A1.2 SCALE: 1/4" = 1'-0"



390 BROGDON RD.,
SUWANEE, GA. 30024

DESIGNER HEREBY EXPRESSLY RESERVES HIS COPYRIGHT AND OTHER PROPERTY RIGHT IN THESE PLANS. THESE PLANS AND DRAWINGS ARE NOT TO BE REPRODUCED, CHANGED OR COPIED IN ANY FORM OR MANNER WHATSOEVER WITHOUT FIRST OBTAINING THE EXPRESS WRITTEN PERMISSION AND CONSENT OF THE DESIGNER. NOR ARE THEY TO BE ASSIGNED TO ANY INTERESTS WITHOUT FIRST OBTAINING SAID WRITTEN PERMISSION AND CONSENT. DESIGN DRAWING CONTENTS SUBJECT TO ALL APPLICABLE CODES, AND APPROVAL BY A LICENSED ENGINEER AND OR ARCHITECT.

SUB-DIVISION Nunnally Farm
LOT # _____

RELEASED FOR CONSTRUCTION

REVISED


THE MAPLEWOOD

JOB NO.	NA	DRAWN	GC
DATE	2/15/2023	CHECKED	DB
SCALE:	AS NOTED	APPROV.	DB

FRONT ELEVATION 'C'

APPROVED BY: DAVID BOWEN
DATE _____


SHEET NO.
A13
SHEET: XX OF XX

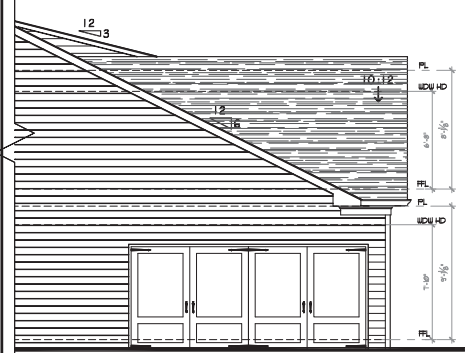


3 Left Side Elevation 'C'
A13 SCALE: 1/4" = 1'-0"



1 Front Elevation 'C'
A13 SCALE: 1/4" = 1'-0"

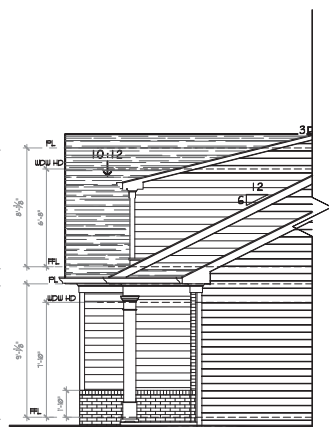

4 Right Side Elevation 'C'
A13 SCALE: 1/4" = 1'-0"

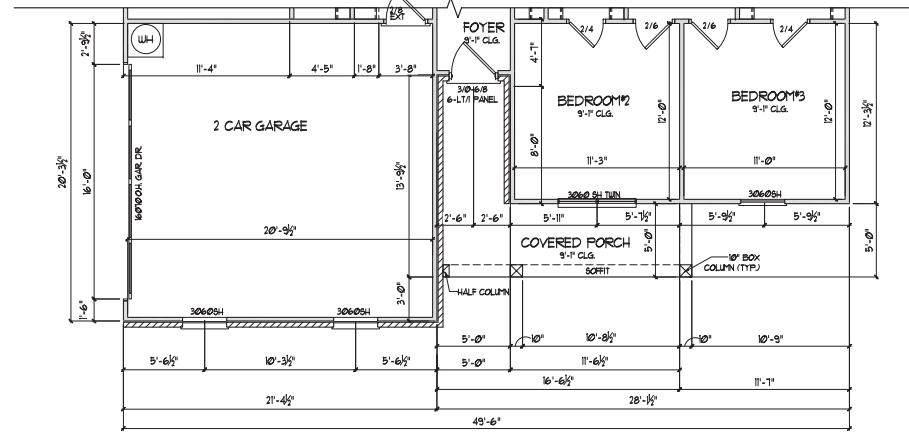

2 1st Floor Plan Elevation 'C'
A13 SCALE: 1/4" = 1'-0"



390 BROGDON RD.,
SUWANEE, GA. 30024

DESIGNER HEREBY EXPRESSLY RESERVES HIS COPYRIGHT AND OTHER PROPERTY RIGHT IN THESE PLANS. THESE PLANS AND DRAWINGS ARE NOT TO BE REPRODUCED, CHANGED OR COPIED IN ANY FORM OR MANNER WHATSOEVER WITHOUT FIRST OBTAINING THE EXPRESS WRITTEN PERMISSION AND CONSENT OF THE DESIGNER. NOR ARE THEY TO BE ASSIGNED TO ANY INTERESTS WITHOUT FIRST OBTAINING SAID WRITTEN PERMISSION AND CONSENT. DESIGN DRAWING CONTENTS SUBJECT TO ALL APPLICABLE CODES, AND APPROVAL BY A LICENSED ENGINEER AND OR ARCHITECT.

SUB-DIVISION Nunnally Farm
LOT # _____

RELEASED FOR CONSTRUCTION

REVISED


THE MAPLEWOOD

JOB NO.	NA	DRAWN	GC
DATE	2/15/2023	CHECKED	DB
SCALE:	AS NOTED	APPROV.	DB

FRONT ELEVATION 'D'

APPROVED BY: DAVID BOWEN
DATE: _____


SHEET NO.
A1.4
SHEET: XX OF: XX

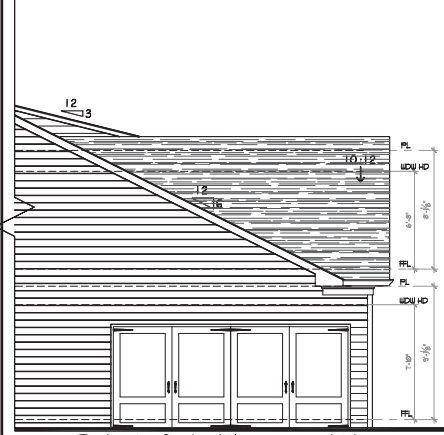


3 Left Side Elevation 'D'
A1.4 SCALE: 1/4" = 1'-0"




1 Front Elevation 'D'
A1.4 SCALE: 1/4" = 1'-0"

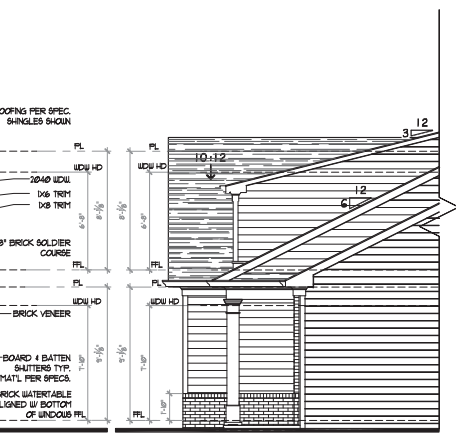


4 Right Side Elevation 'D'
A1.4 SCALE: 1/4" = 1'-0"

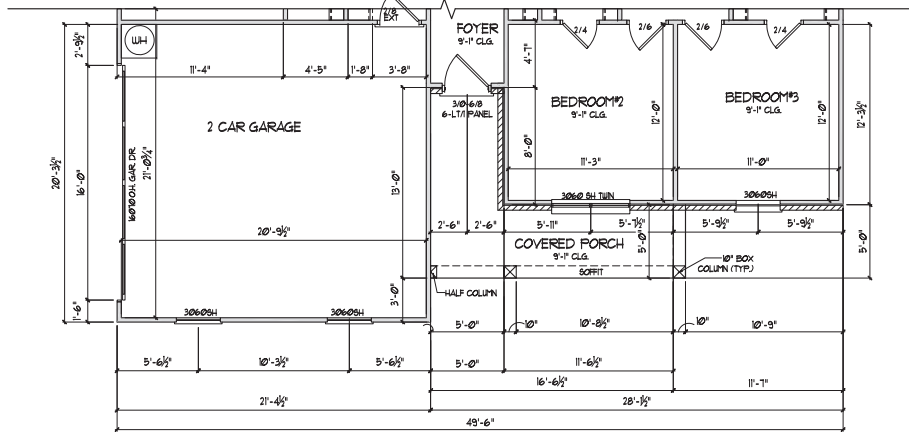


2 1st Floor Plan Elevation 'D'
A1.4 SCALE: 1/4" = 1'-0"

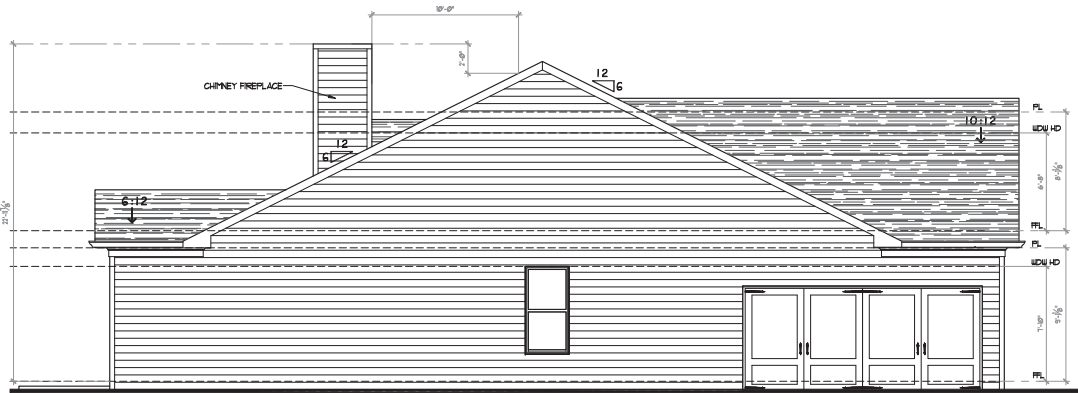


1 Left Side Elevation 'A' & 'B'
 A21 SCALE: 1/4" = 1'-0"

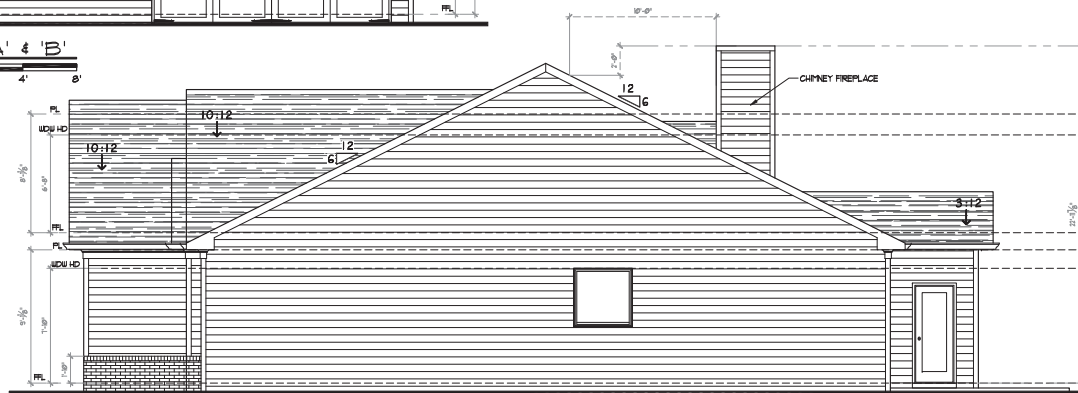

2 Right Side Elevation 'A' & 'B'
 A21 SCALE: 1/4" = 1'-0"

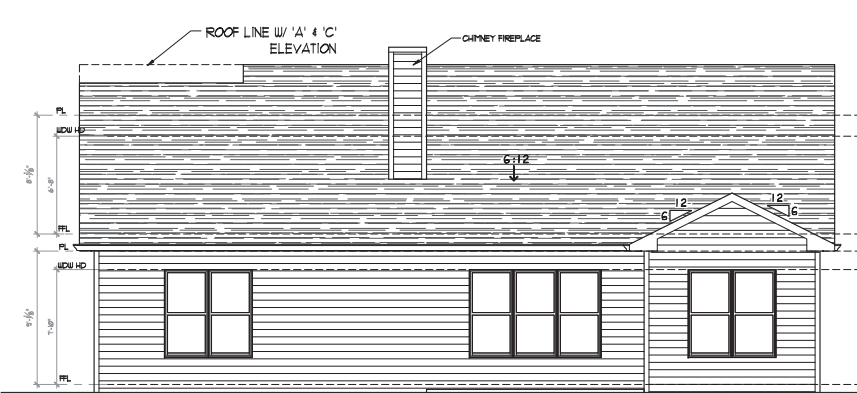

3 Rear Elevation - Standard
 A21 SCALE: 1/4" = 1'-0"

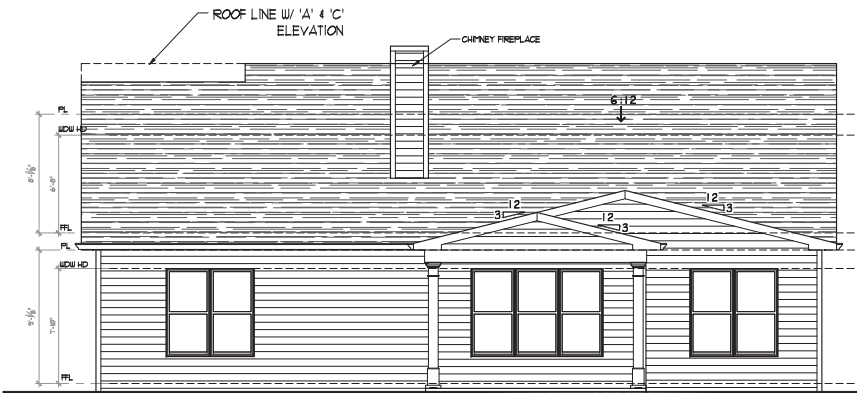

4 Rear Elevation w/ Covered Porch Option
 A21 SCALE: 1/4" = 1'-0"



390 BROGDON RD,
 SUWANEE, GA. 30024

DESIGNER HEREBY EXPRESSLY RESERVES HIS COPYRIGHT AND OTHER PROPERTY RIGHT IN THESE PLANS. THESE PLANS AND DRAWINGS ARE NOT TO BE REPRODUCED, CHANGED OR COPIED IN ANY FORM OR MANNER WHATSOEVER WITHOUT FIRST OBTAINING THE EXPRESS WRITTEN PERMISSION AND CONSENT OF THE DESIGNER. NOR ARE THEY TO BE ASSIGNED TO ANY INTERESTS WITHOUT FIRST OBTAINING SAID WRITTEN PERMISSION AND CONSENT. DESIGN DRAWING CONTENTS SUBJECT TO ALL APPLICABLE CODES, AND APPROVAL BY A LICENSED ENGINEER AND OR ARCHITECT.

SUB-DIVISION Nunnally Farm
 LOT #

RELEASED FOR CONSTRUCTION

REVISED

THE MAPLEWOOD

JOB NO.	NA	DRAWN	GC
DATE	2/15/2023	CHECKED	DB
SCALE:	AS NOTED	APROV.	DB

SIDE & REAR ELEVATIONS 'A' & 'B'

APPROVED BY: DAVID BOWEN
 DATE:

SHEET NO.
A2.1
 SHEET: XX. OF. XX.



390 BROGDON RD.,
SUWANEE, GA. 30024

DESIGNER HEREBY EXPRESSLY RESERVES HIS COPYRIGHT AND OTHER PROPERTY RIGHT IN THESE PLANS. THESE PLANS AND DRAWINGS ARE NOT TO BE REPRODUCED, CHANGED OR COPIED IN ANY FORM OR MANNER WHATSOEVER WITHOUT FIRST OBTAINING THE EXPRESS WRITTEN PERMISSION AND CONSENT OF THE DESIGNER. NOR ARE THEY TO BE ASSIGNED TO ANY INTERESTS WITHOUT FIRST OBTAINING SAID WRITTEN PERMISSION AND CONSENT. DESIGN DRAWING CONTENTS SUBJECT TO ALL APPLICABLE CODES, AND APPROVAL BY A LICENSED ENGINEER AND OR ARCHITECT.

SUB-DIVISION Nunnally Farm
LOT #

RELEASED FOR CONSTRUCTION

REVISED

THE MAPLEWOOD

JOB NO.	NA	DRAWN	GC
DATE	2/15/2023	CHECKED	DB
SCALE:	AS NOTED	APPROV.	DB

SIDE & REAR ELEVATIONS 'C' & 'D'


APPROVED BY: DAVID BOWEN

DATE:


SHEET NO.

A2.2


SHEET: XX OF XX

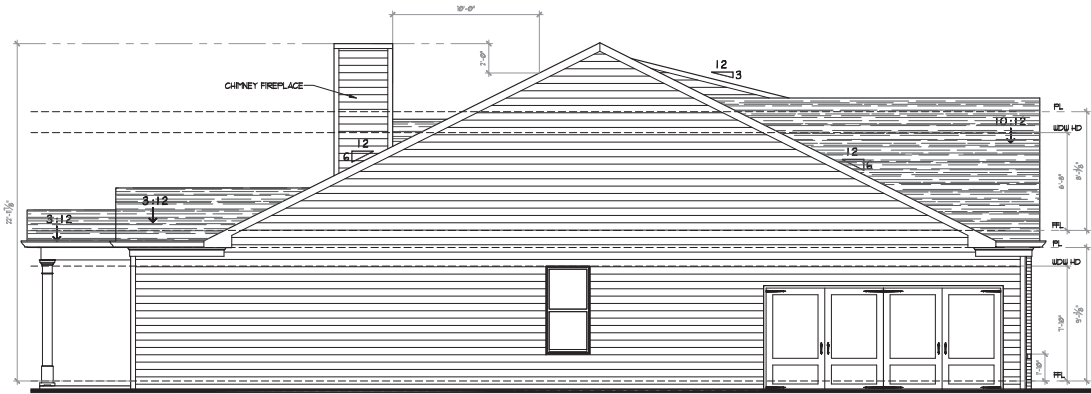


1 Left Side Elevation 'C' & 'D'
A2.2 SCALE: 1/4" = 1'-0"

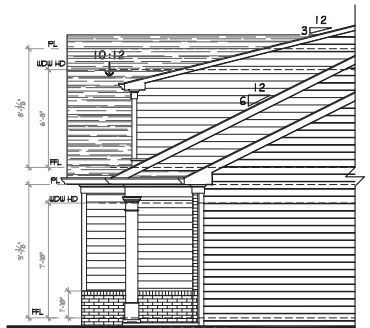


2 Right Side Elevation 'D'
A2.2 SCALE: 1/4" = 1'-0"

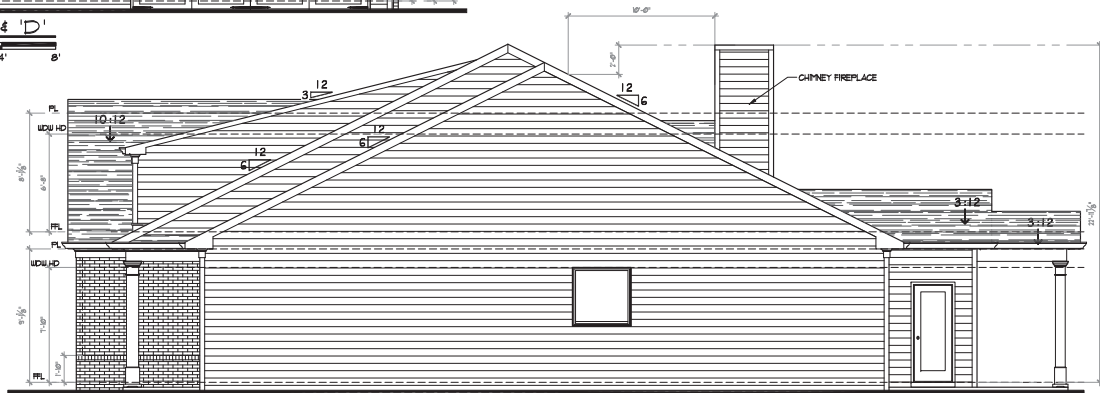


2 Right Side Elevation 'C'
A2.2 SCALE: 1/4" = 1'-0"

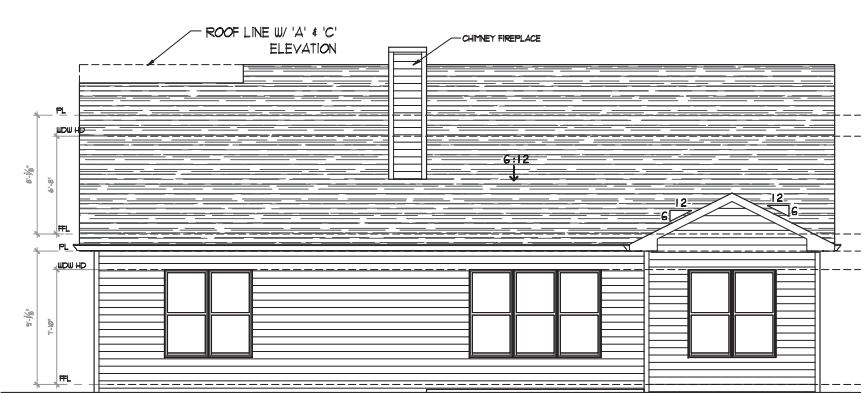


3 Rear Elevation - Standard
A2.1 SCALE: 1/4" = 1'-0"

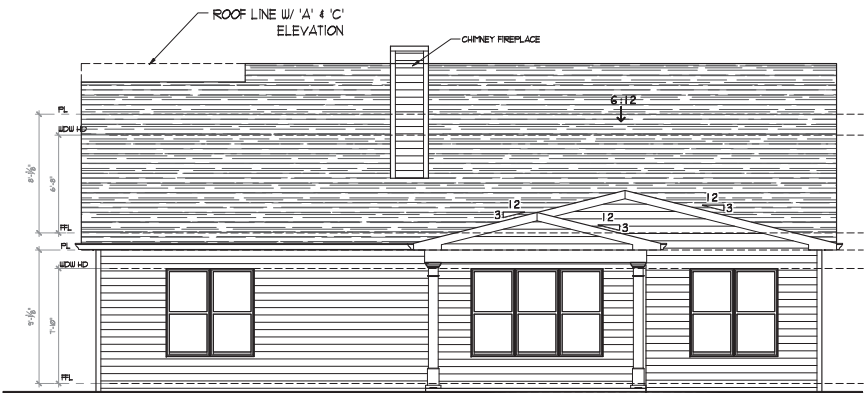


4 Rear Elevation w/ Covered Porch Option
A2.1 SCALE: 1/4" = 1'-0"

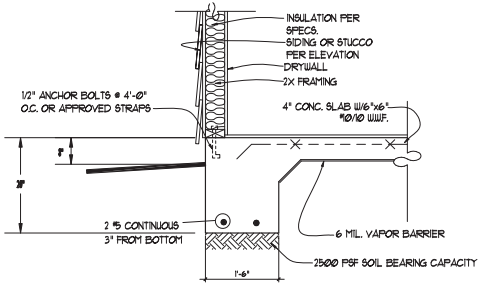


2 TURNDOWN SLAB SECTION W/O BRICK VENEER
SCALE: NTS

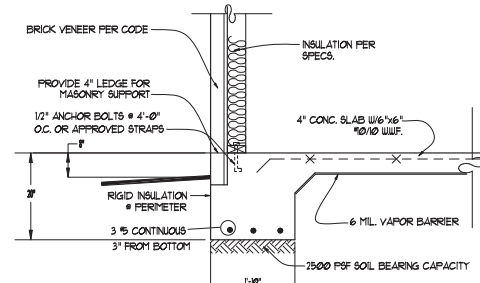


3 TURNDOWN SLAB SECTION W/ BRICK VENEER
SCALE: NTS

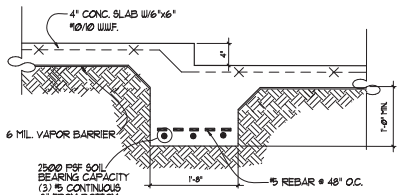


4 STEPPED SLAB SECTION
SCALE: NTS

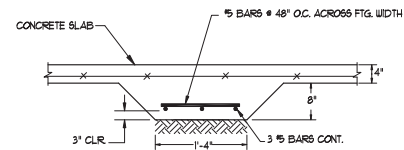

5 INTERIOR GRADE BEAM
SCALE: NTS

 

6 TYPICAL SLAB ON GRADE
SCALE: NTS

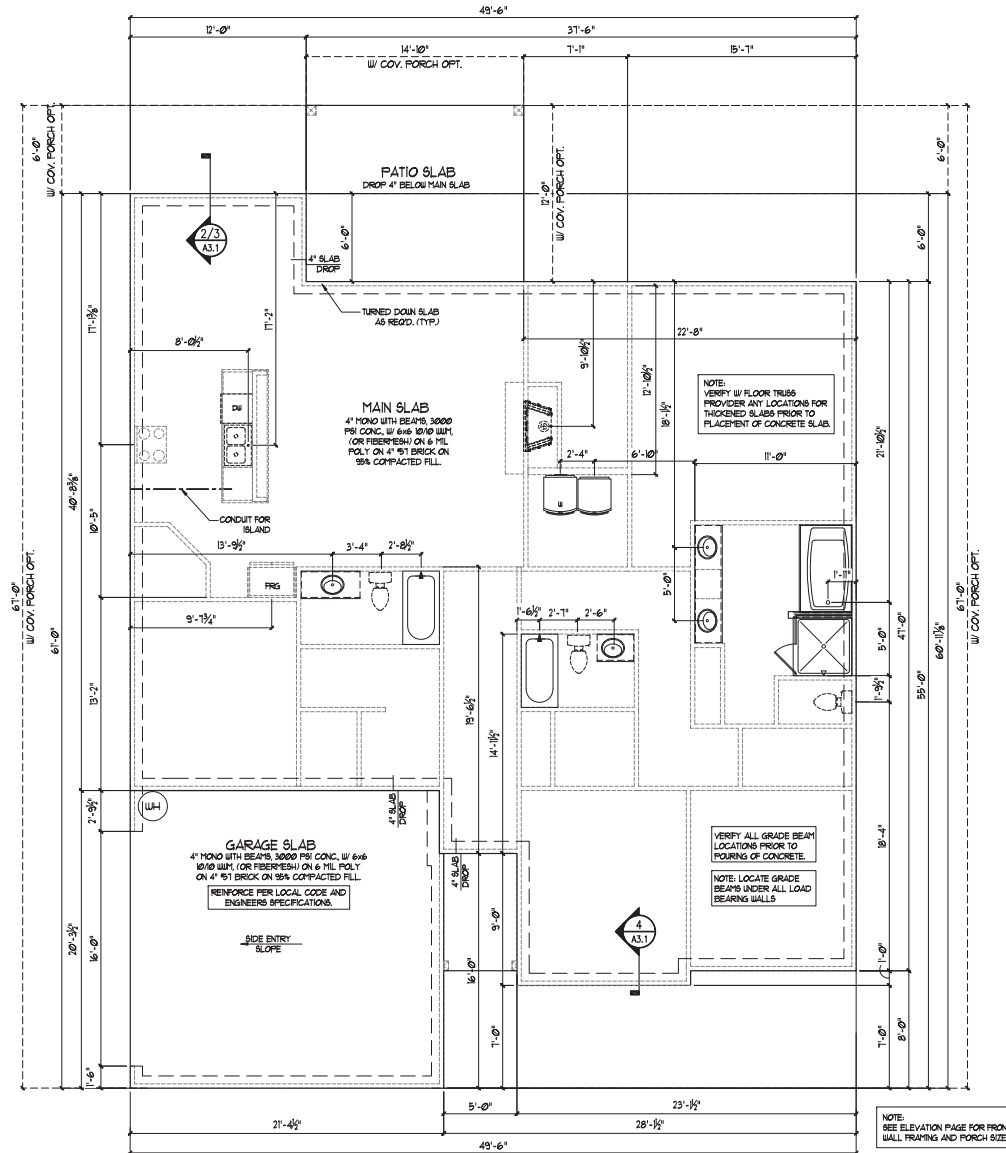

1 Slab Foundation Plan
SCALE: 1/4" = 1'-0"



390 BROGDON RD.,
SUWANEE, GA. 30024

DESIGNER HEREBY EXPRESSLY RESERVES HIS COPYRIGHT AND OTHER PROPERTY RIGHT IN THESE PLANS. THESE PLANS AND DRAWINGS ARE NOT TO BE REPRODUCED, CHANGED OR COPIED IN ANY FORM OR MANNER WHATSOEVER WITHOUT FIRST OBTAINING THE EXPRESS WRITTEN PERMISSION AND CONSENT OF THE DESIGNER. NOR ARE THEY TO BE ASSIGNED TO ANY INTERESTS WITHOUT FIRST OBTAINING SAID WRITTEN PERMISSION AND CONSENT. DESIGN DRAWING CONTENTS SUBJECT TO ALL APPLICABLE CODES, AND APPROVAL BY A LICENSED ENGINEER AND OR ARCHITECT.

SUB-DIVISION Nunnally Farm
LOT #

RELEASED FOR CONSTRUCTION

REVISED


THE MAPLEWOOD

JOB NO.	NA	DRAWN	GC
DATE	2/15/2023	CHECKED	DB
SCALE:	AS NOTED	APPROV.	DB

SLAB FOUNDATION PLAN

APPROVED BY: DAVID BOWEN
DATE:

SHEET NO.
A3.1
SHEET: XX OF XX

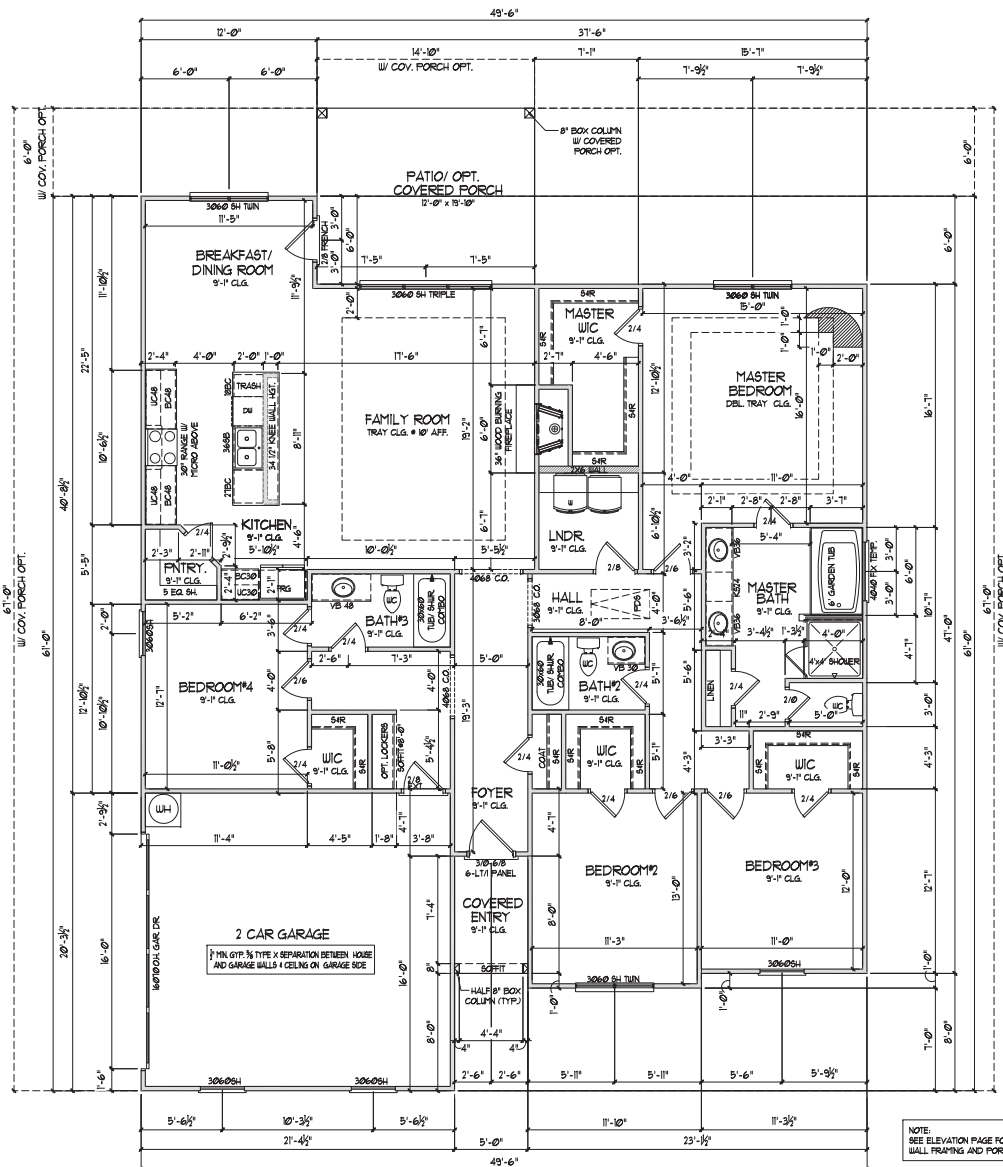

SQUARE FOOTAGE	
MAIN LEVEL	2,108
TOTAL HEATED	2,188
2 CAR GARAGE	432
FRONT PORCH	40
TOTAL FRAMED	2,560
OPT. NEAR COVERED PORCH	56

NOTE:
SEE ELEVATION PAGE FOR FRONT
WALL FRAMING AND PORCH SIZE

1st Floor Plan
SCALE: 1/4" = 1'-0"



390 BROGDON RD.,
SUWANEE, GA. 30024

DESIGNER HEREBY EXPRESSLY RESERVES HIS COPYRIGHT AND OTHER PROPERTY RIGHT IN THESE PLANS. THESE PLANS AND DRAWINGS ARE NOT TO BE REPRODUCED, CHANGED OR COPIED IN ANY FORM OR MANNER WHATSOEVER WITHOUT FIRST OBTAINING THE EXPRESS WRITTEN PERMISSION AND CONSENT OF THE DESIGNER. NOR ARE THEY TO BE ASSIGNED TO ANY INTERESTS WITHOUT FIRST OBTAINING SAID WRITTEN PERMISSION AND CONSENT. DESIGN DRAWING CONTENTS SUBJECT TO ALL APPLICABLE CODES, AND APPROVAL BY A LICENSED ENGINEER AND OR A R C H I T E C T.

SUB-DIVISION Nunnally Farm
LOT #

RELEASED FOR CONSTRUCTION
REVISED


THE MAPLEWOOD

JOB NO.	NA	DRAWN	GC
DATE	2/15/2023	CHECKED	DB
SCALE:	AS NOTED	APPROV.	DB


MAIN LEVEL FLOOR PLAN

APPROVED BY: DAVID BOWEN
DATE:

SHEET NO.
A4.1
SHEET: XX OF: XX

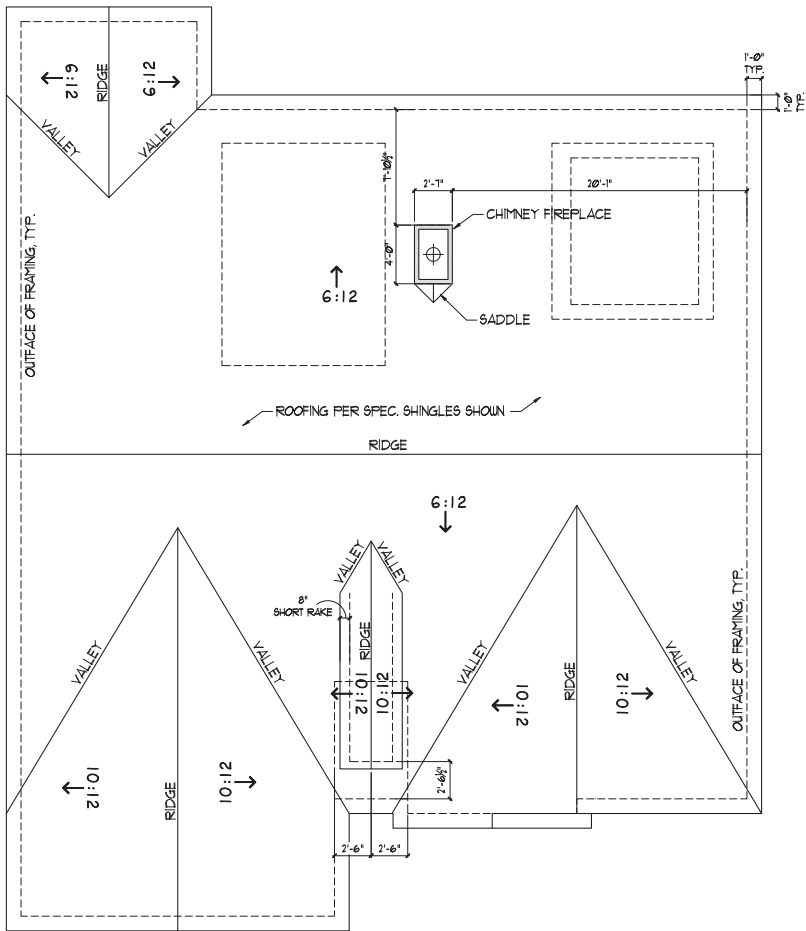

1 Roof Plan Elevation 'A' & 'B' - Standard
SCALE: 1/4" = 1'-0"

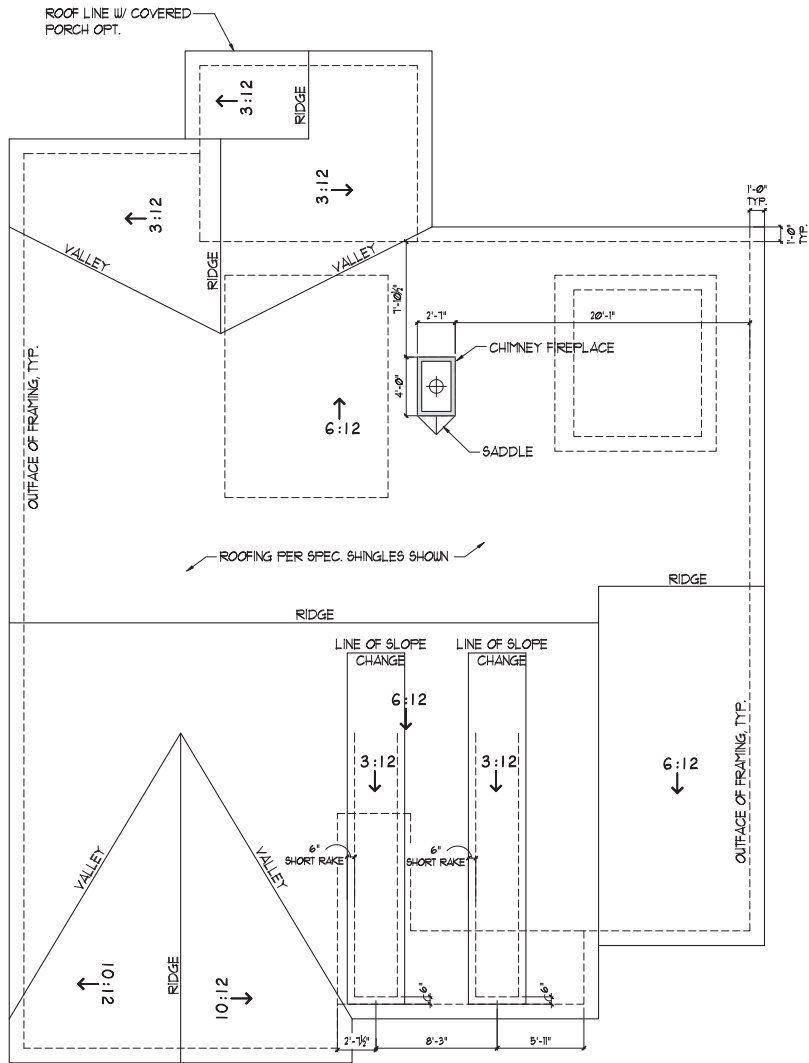

2 Roof Plan Elevation 'C' & 'D' - w/ Covered Porch Opt.
SCALE: 1/4" = 1'-0"



390 BROGDON RD.,
SUWANEE, GA. 30024

DESIGNER HEREBY EXPRESSLY RESERVES HIS COPYRIGHT AND OTHER PROPERTY RIGHT IN THESE PLANS. THESE PLANS AND DRAWINGS ARE NOT TO BE REPRODUCED, CHANGED OR COPIED IN ANY FORM OR MANNER WHATSOEVER WITHOUT FIRST OBTAINING THE EXPRESS WRITTEN PERMISSION AND CONSENT OF THE DESIGNER. NOR ARE THEY TO BE ASSIGNED TO ANY INTERESTS WITHOUT FIRST OBTAINING SAID WRITTEN PERMISSION AND CONSENT. DESIGN DRAWING CONTENTS SUBJECT TO ALL APPLICABLE CODES, AND APPROVAL BY A LICENSED ENGINEER AND OR ARCHITECT.

SUB-DIVISION Nunnally Farm
LOT #

RELEASED FOR CONSTRUCTION

REVISED

THE MAPLEWOOD

JOB NO.	NA	DRAWN	GC
DATE	2/15/2023	CHECKED	DB
SCALE:	AS NOTED	APPROV.	DB

ROOF PLANS


APPROVED BY: DAVID BOWEN

DATE:

SHEET NO.

A5.1

SHEET: XX OF: XX

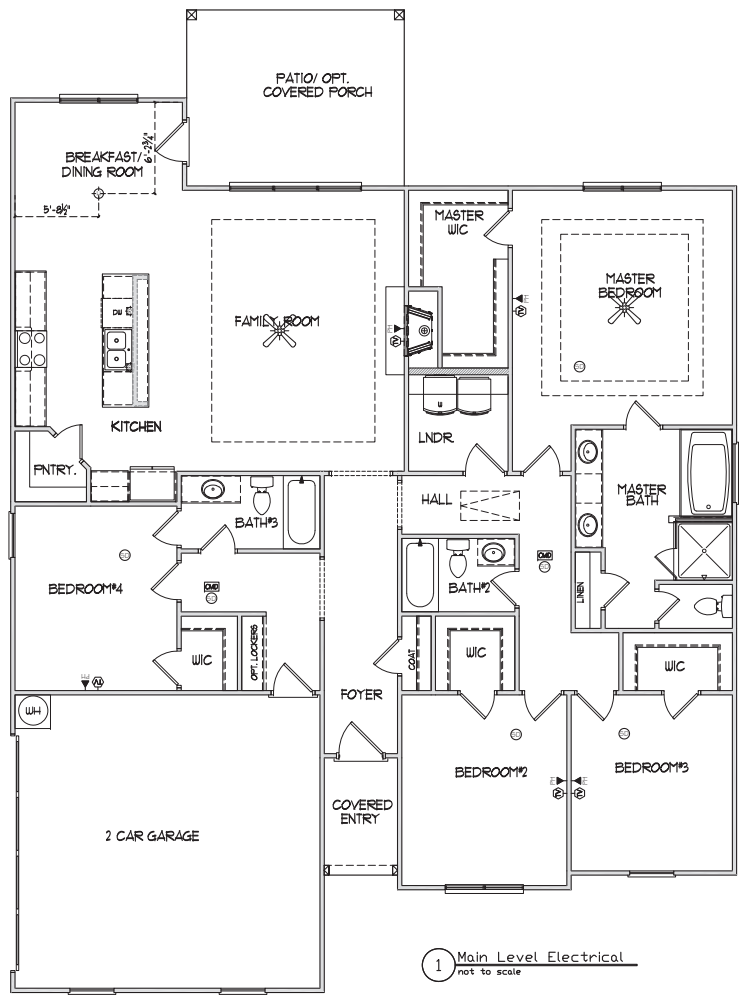

1 Main Level Electrical
not to scale

ELECTRICAL LEGEND			
—GAS	Gas Line	☐	Recessed Can Light
—CW	Cold Water	⊙	Eyeball Light
—	Electrical Panel	⊕	Wall Mounted Light
—	Electrical Meter	⊖	Wall Sconce
—	Disconnect Switch	— —	Fluorescent Light w/1 Bulb
—	Switch	— — —	Fluorescent Light w/2 Bulbs
—	3-Way Switch	⊕	Vapor Protected Light
—	4-Way Switch	⊖	Exhaust Fan
—	Dimmer Switch	⊕	Exhaust Fan w/Light
⊕	Button	⊖	Exhaust Fan w/Heat & Light
⊕	Duplex Outlet	⊕	Smoke Detector
⊕	Quadplex Outlet	⊕	Carbon Monoxide Detector
⊕	Switched Duplex Outlet	⊕	Thermostat
FLOOR	Floor Outlet	⊕	Direct Wire
GFI	GFI Outlet	⊕	Phone Jack
WP-GFI	Water Proof GFI Outlet	⊕	Media Jack
CLC	Ceiling Mounted Outlet	⊕	Cable TV Outlet
220V	220V Outlet	⊕	Door Chimes
⊕	Ceiling Mounted Light	⊕	Security Panel
⊕	Hanging Ceiling Mounted Light	⊕	Flood Light
⊕	Ceiling Fan	⊕	Ceiling Fan w/Light

**390 BROGDON RD.,
SUWANEE, GA. 30024**

DESIGNER HEREBY EXPRESSLY RESERVES HIS COPYRIGHT AND OTHER PROPERTY RIGHT IN THESE PLANS. THESE PLANS AND DRAWINGS ARE NOT TO BE REPRODUCED, CHANGED OR COPIED IN ANY FORM OR MANNER WHATSOEVER WITHOUT FIRST OBTAINING THE EXPRESS WRITTEN PERMISSION AND CONSENT OF THE DESIGNER. NOR ARE THEY TO BE ASSIGNED TO ANY INTERESTS WITHOUT FIRST OBTAINING SAID WRITTEN PERMISSION AND CONSENT. DESIGN DRAWING CONTENTS SUBJECT TO ALL APPLICABLE CODES, AND APPROVAL BY A LICENSED ENGINEER AND OR ARCHITECT.

SUB-DIVISION Nunnally Farm
LOT # _____

RELEASED FOR CONSTRUCTION

REVISED

THE MAPLEWOOD

JOB NO.	NA	DRAWN	GC
DATE	2/15/2023	CHECKED	DB
SCALE:	AS NOTED	APPROV.	DB

ELECTRICAL PLANS

APPROVED BY: DAVID BOWEN
DATE: _____

SHEET NO.
A6.1
SHEET: XX OF: XX