

1 FLOOR PLAN (WAREHOUSE)
 A1 SCALE: 1/16"=1'-0"

REVISIONS		
NO.	DATE	DESCRIPTION

MFG
 MACON E. GOUGH III
 BUILDING ARCHITECTS
 1500 W. RAILROAD AVENUE
 SUITE 2000
 MACON, GEORGIA 31201
 TEL: 478-474-1000 FAX: 478-474-1006

4/28/24


510x120' METAL BUILDING DESIGN
 LD WELDING SERVICES
 FLOOR PLAN - WAREHOUSE
 2847202101
 HALL COUNTY, GEORGIA 30507

DESIGN	MEG	4/28/24
DRAWN	RSL	4/28/24
CHECKED	BSR	4/28/24
DATE	4/28/24	
PROJECT #:	02405189486	
SHEET	A1 of XX	


NOT RELEASED FOR CONSTRUCTION

C:\Users\edwards\appdata\local\temp\6d6b46a6-2d32-3951-Mason-Hay-Drawing-Set-P-30-24.dwg Thu, 02/22/24 4:54 PM

C:\Users\conradh3\appdata\local\temp\appdata\local\temp\22432\2811 Athens Hwy - Drawing Set 8-20-24.dwg Thu, 08/22/24 4:54 PM

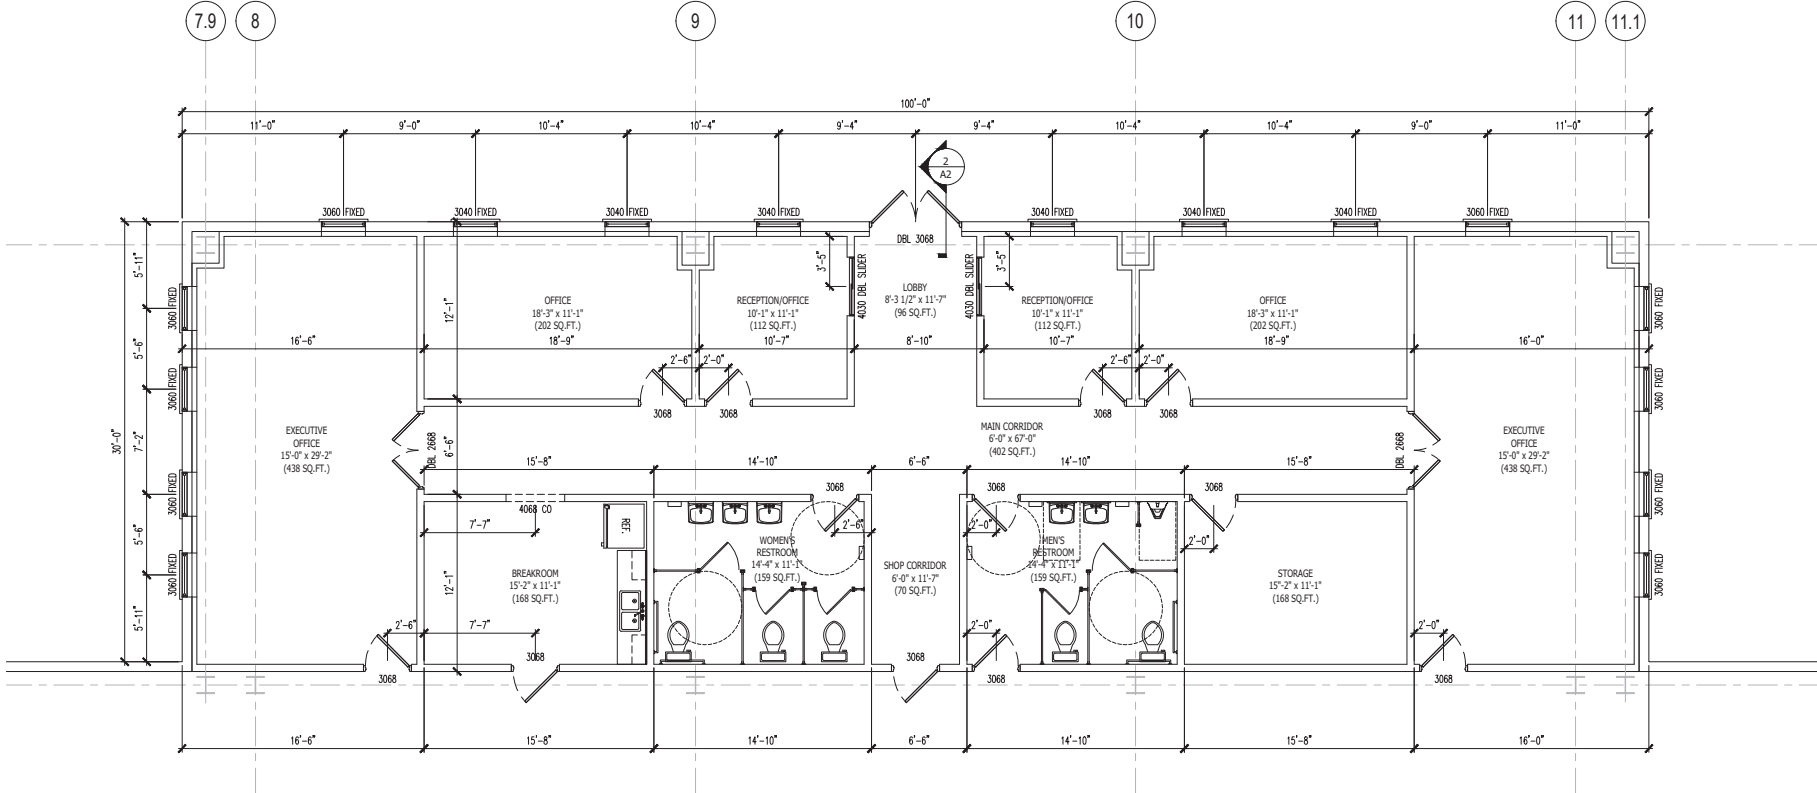

1 FLOOR PLAN (OFFICE)
A2 SCALE: 1/4"=1'-0"

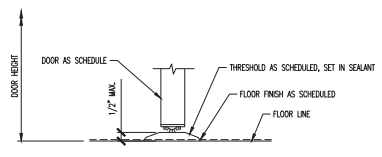

2 DOOR THRESHOLD DETAIL
A2 SCALE: N.T.S.

THESE CONSTRUCTION DOCUMENTS ARE PREPARED IN WHOLE OR IN PART BY MEG BUILDING CONSULTANTS AND THE SOLE PROPERTY OF MEG AND THE USER SHALL BE RESPONSIBLE FOR THE ACCURACY OF THE INFORMATION CONTAINED HEREIN. MEG SHALL NOT BE RESPONSIBLE FOR ANY OMISSIONS OR ERRORS IN THE INFORMATION CONTAINED HEREIN. THE USER SHALL BE RESPONSIBLE FOR THE ACCURACY OF THE INFORMATION CONTAINED HEREIN. THE USER SHALL BE RESPONSIBLE FOR THE ACCURACY OF THE INFORMATION CONTAINED HEREIN. THE USER SHALL BE RESPONSIBLE FOR THE ACCURACY OF THE INFORMATION CONTAINED HEREIN.

REVISION	DATE	APPROVED	DESCRIPTION

MACON E. GOOCH III
BUILDING CONSULTANTS
2811 ATHENS HWY
ALBANY, GEORGIA 31707
TEL: 678-442-1198 FAX: 678-295-7485




6/28/24

510'x120' METAL BUILDING DESIGN
LD WELDING SERVICES
FLOOR PLAN - OFFICE
2811 ATHENS HWY
ALBANY, GEORGIA 31707
TEL: 678-442-1198 FAX: 678-295-7485

DESIGN	MEG	6/28/24
DRAWN	RSL	6/28/24
CHECKED	BSR	6/28/24
DATE:	6/28/24	
PROJECT #:	D240518948	

SHEET
A2 OF X

NOT RELEASED FOR CONSTRUCTION

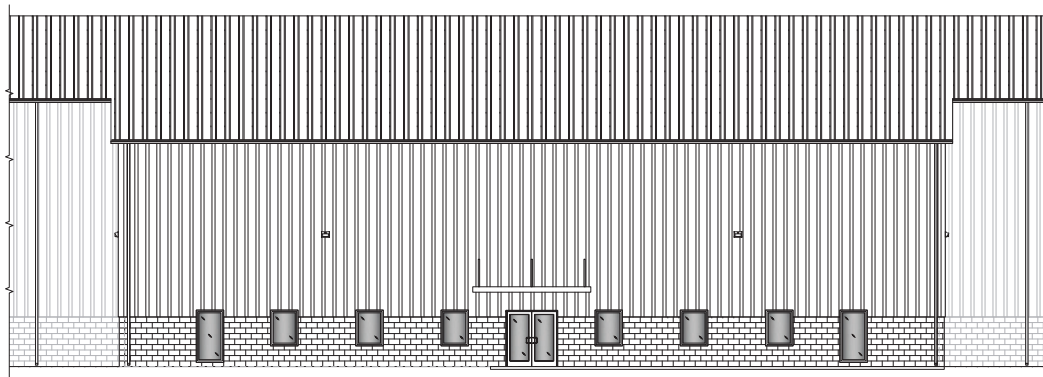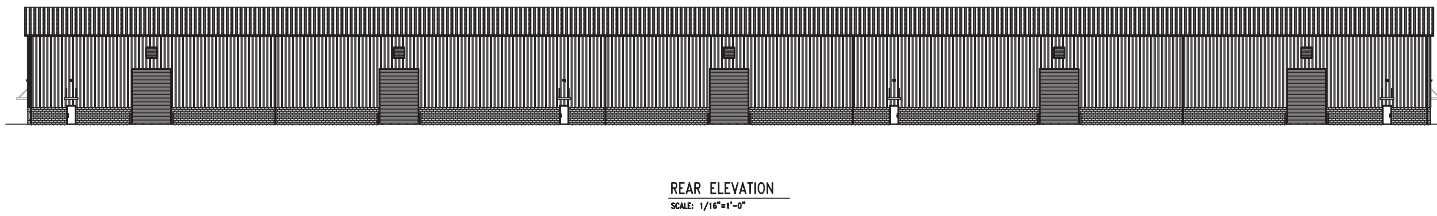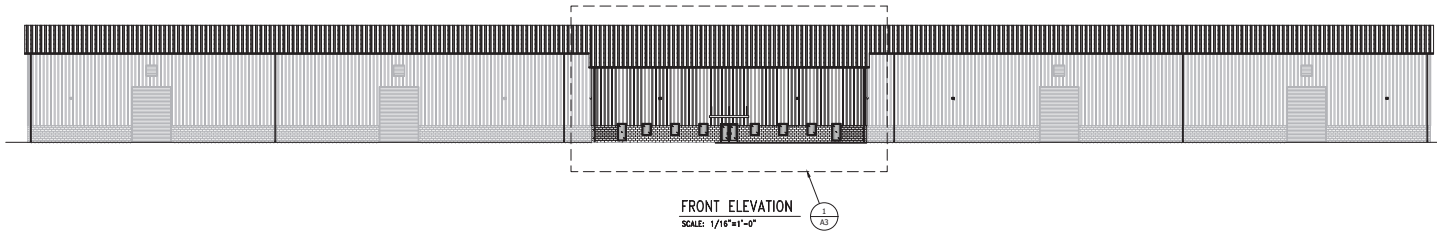

NO.	REV.	DATE	DESCRIPTION


MACON E. GOOCH III
 BUILDING CONSULTANTS
 2817 ARENS WAY
 MAZON, GEORGIA 30551
 TEL: 478-442-1188 FAX: 478-442-1486


4/28/24

5'0\"/>


DESIGN	MEG	6/28/24
DRAWN	BSR	4/28/24
CHECKED	BSR	4/28/24
DATE	6/28/24	
PROJECT #	02425189486	

SHEET
A3 of XX

NOT RELEASED FOR CONSTRUCTION

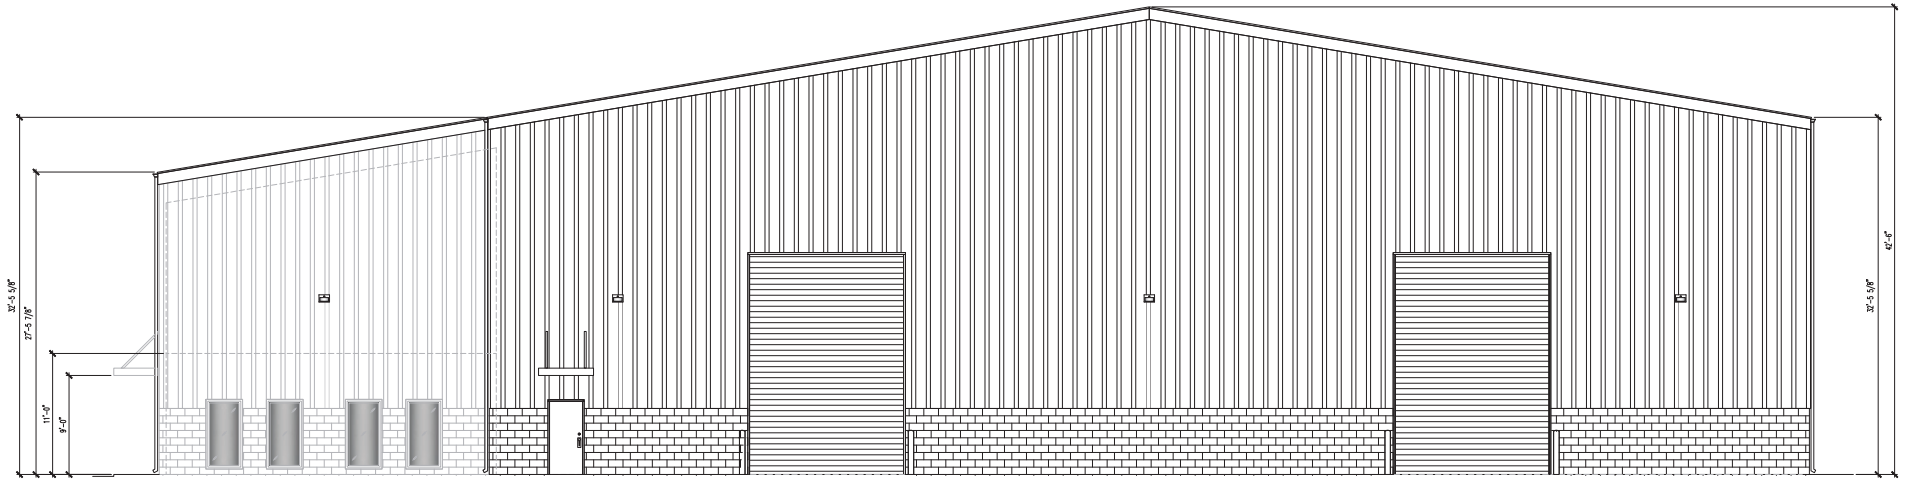

RIGHT ELEVATION
SCALE: 3/16"=1'-0"

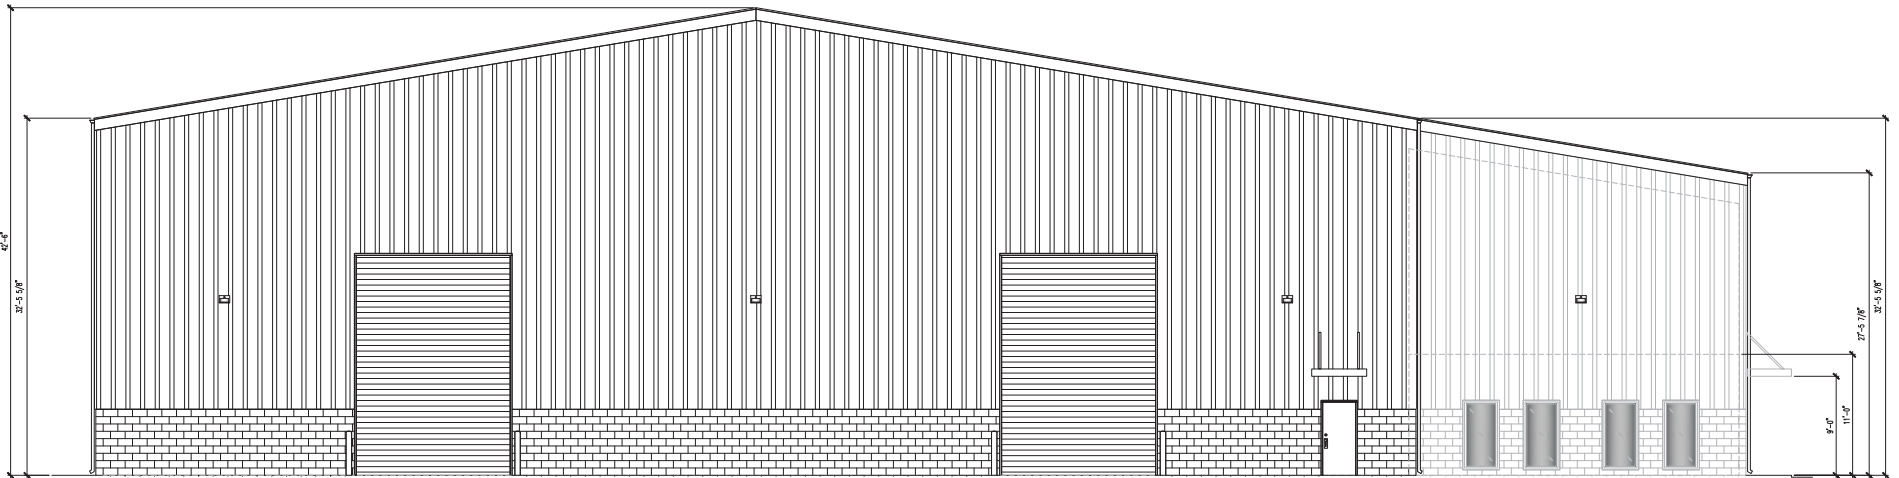

LEFT ELEVATION
SCALE: 1/4"=1'-0"

REVISION	DATE	APPROVED	DESCRIPTION


MACON E. GOUGH III
 BUILDING CONSULTANTS
 2817 ARENS HWY. #11
 HALL COUNTY, GEORGIA 30501
 TEL: 678-402-1188 FAX: 678-342-1468


5'0"X120' METAL BUILDING DESIGN
LD WELDING SERVICES
ELEVATIONS
6911
2817 ARENS HWY. #11
HALL COUNTY, GEORGIA 30507

DESIGN	MEG	6/28/24
DRAWN	RSL	6/28/24
CHECKED	BSR	6/28/24
DATE		6/28/24
PROJECT #		02425189486




SHEET **A4** OF **XX**

NOT RELEASED FOR CONSTRUCTION

C:\Users\candrea3\OneDrive\LocalTemp\A5Publish_22432\2811 Athens Hwy - Drawing Set 8-20-24.dwg Thu, 08/22/24 4:54 PM

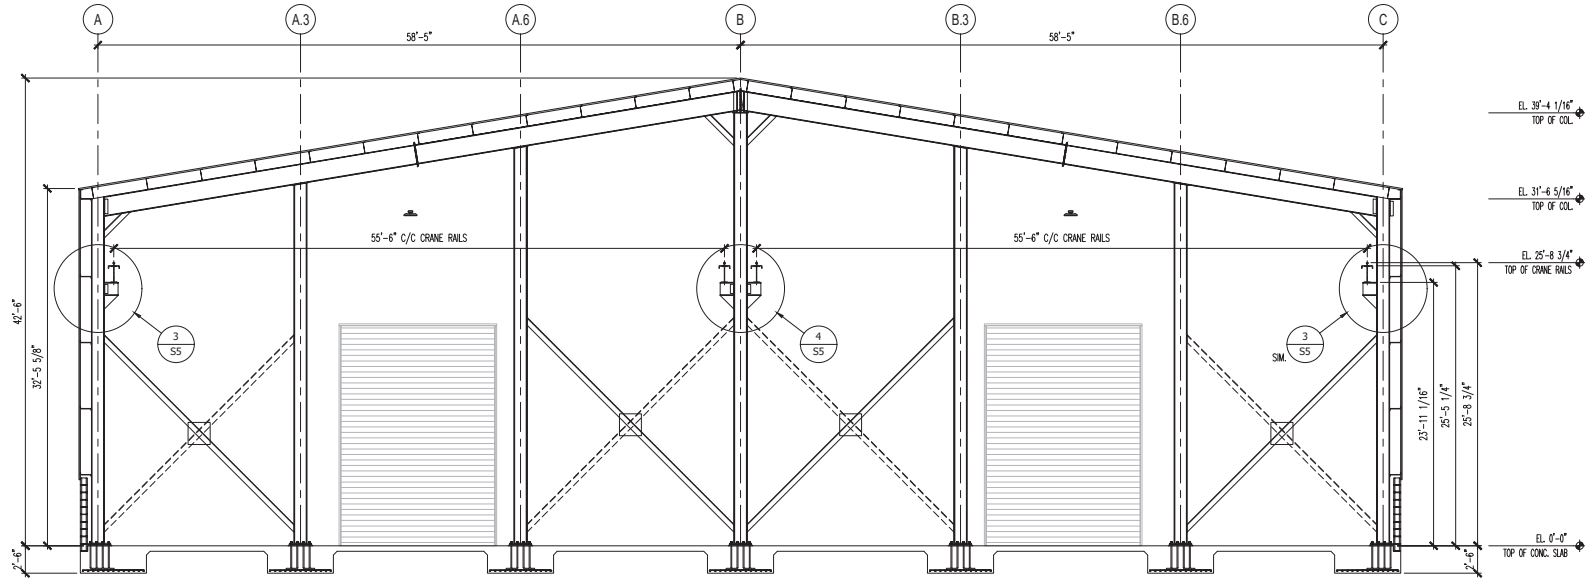

1 BUILDING CROSS SECTION (WAREHOUSE)
A5 SCALE: 3/16"=1'-0"

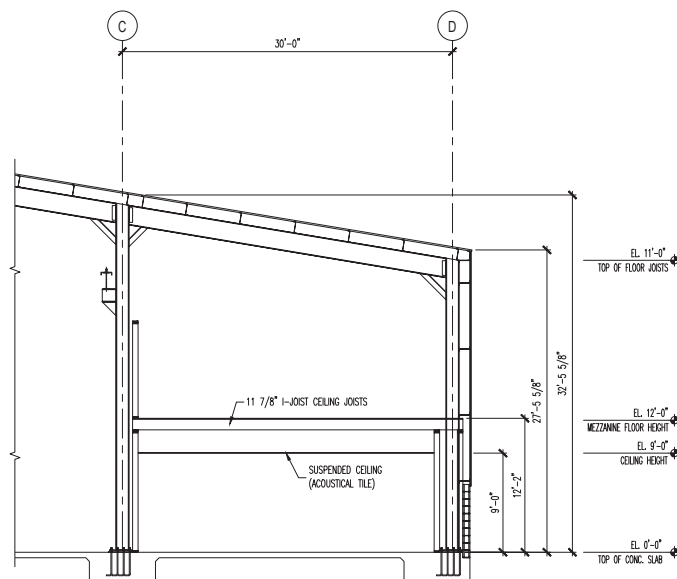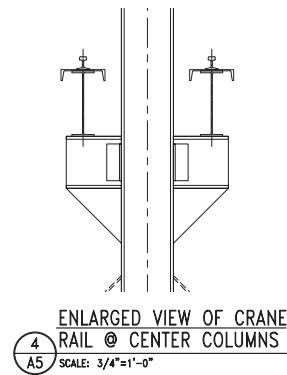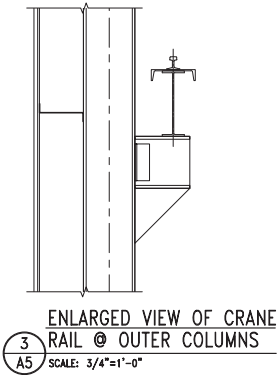

2 BUILDING CROSS SECTION (OFFICE)
A5 SCALE: 3/16"=1'-0"

THESE CONSTRUCTION DOCUMENTS ARE PREPARED EXCLUSIVELY IN WAZEE AND THE SOLE PROPERTY OF MACON E. GOOCH III BUILDING CONSULTANTS. ANY REUSE OR REPRODUCTION OF THESE DOCUMENTS WITHOUT THE WRITTEN PERMISSION FROM THE ARCHITECT IS STRICTLY PROHIBITED. SEE THE NOTES FOR ANY OTHER PROJECTS OTHER THAN THAT WHICH IS IDENTIFIED IN THESE DOCUMENTS. SEE CONSULTANTS' LIST FOR A COMPLETE LIST OF PROJECTS.

REVISION	DATE	APPROVED	DESCRIPTION

MACON E. GOOCH III
BUILDING CONSULTANTS
ALBANY, GEORGIA 31701
TEL: 678-442-1198 FAX: 678-295-7485

6/28/24

510'x120' METAL BUILDING DESIGN
LD WELDING SERVICES
BUILDING SECTION


2811 ATHENS HWY
HALL COUNTY, GEORGIA 30507

DESIGN	MEG	6/28/24
DRAWN	RSL	6/28/24
CHECKED	BSR	6/28/24
DATE:	6/28/24	
PROJECT #:	D240518948	
SHEET	1 of 4	

A5 of X

NOT RELEASED FOR CONSTRUCTION

C:\Users\candrea3\OneDrive\Local\Temp\A6Publish_22432\2811 Athens Hwy - Drawing Set 8-20-24.dwg Thu, 08/22/24 4:54 PM

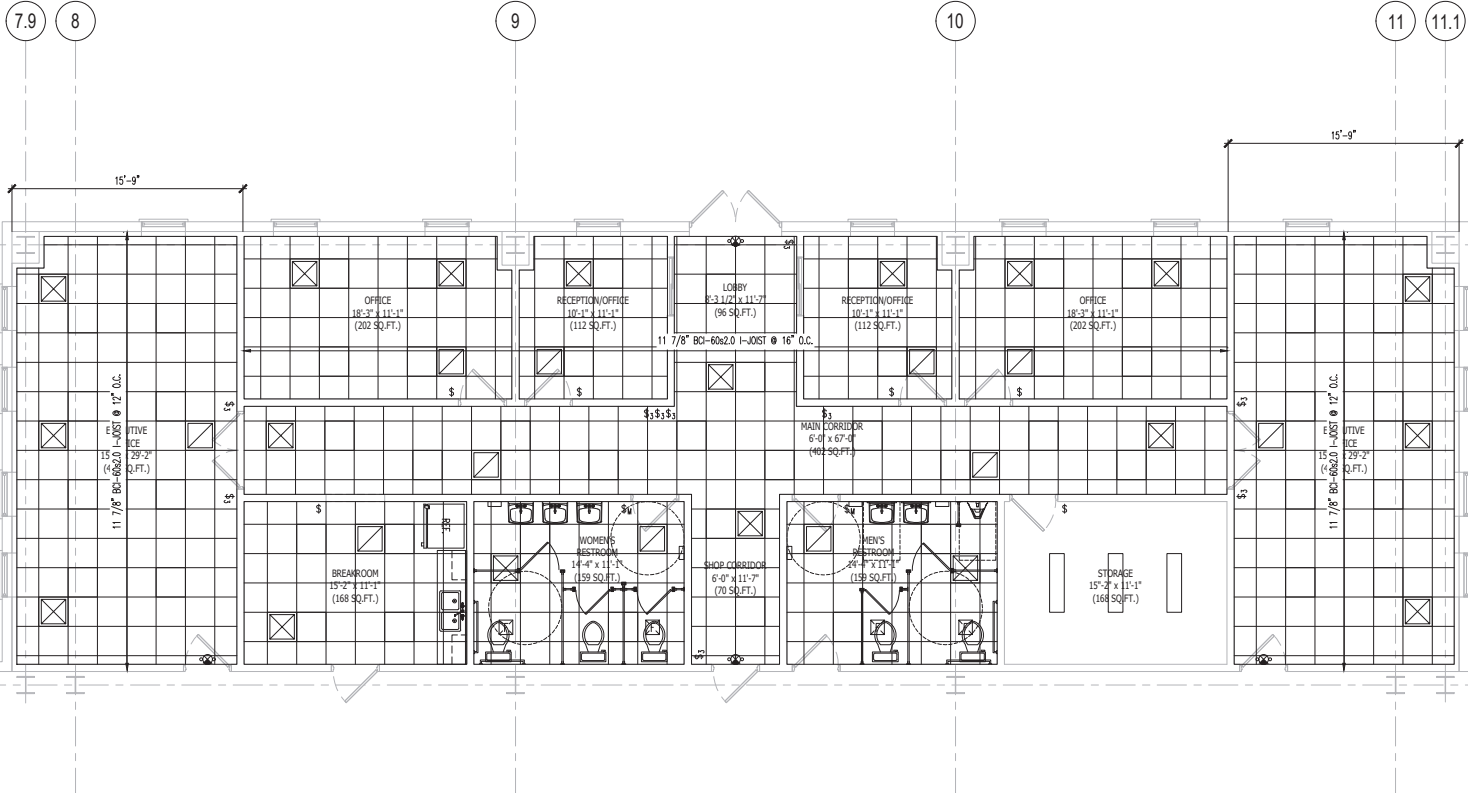

1 REFLECTED CEILING PLAN (OFFICE)
A6 SCALE: 1/4"=1'-0"

REFLECTIVE CEILING PLAN LEGEND	
SYMBOL	DESCRIPTION
	LED TROFFER, 2'x2'
	LED TROFFER, 2'x2' (SECURITY CIRCUIT)
	SUPPLY DIFFUSER - 2'x2'
	RETURN DIFFUSER - 2'x2'
	RECESSED LED CAN LIGHT
	EXHAUST FAN
	CEILING MOUNTED LED - 6" x 8"
	EXIT SIGN
	SMOKE/CO DETECTOR
	EMERGENCY LIGHT
(A)	CEILING TYPE "A" GYPSUM BOARD WITH WHITE PAINTED FINISH
(B)	CEILING TYPE "B" ARMSTRONGS 2'x2' WHITE GRID W/ 2'x2' ACOUSTICAL TILE

NOT RELEASED FOR CONSTRUCTION

REVISION	DATE	APPROVED	DESCRIPTION

MACON E. GOOCH III
 BUILDING CONSULTANTS
 2811 ATHENS HWY
 ALBANY, GEORGIA 30501
 TEL: 678-442-1198 FAX: 678-295-7485

6/28/24

510'x120' METAL BUILDING DESIGN
 LD WELDING SERVICES
 REFLECTED CEILING PLAN - OFFICE

2811 ATHENS HWY
 HALL COUNTY, GEORGIA 30507


DESIGN	MEG	6/28/24
DRAWN	RSL	6/28/24
CHECKED	BSR	6/28/24
DATE:	6/28/24	
PROJECT #:	D240518948	
SHEET		

A6 of **X**


THESE DOCUMENTS ARE THE PROPERTY OF MEG ENGINEERS AND ARCHITECTS. NO PART OF THESE DOCUMENTS IS TO BE REPRODUCED OR TRANSMITTED IN ANY FORM OR BY ANY MEANS, ELECTRONIC OR MECHANICAL, INCLUDING PHOTOCOPYING, RECORDING, OR BY ANY INFORMATION STORAGE AND RETRIEVAL SYSTEM, WITHOUT THE WRITTEN PERMISSION OF MEG ENGINEERS AND ARCHITECTS.

NO.	DATE	REVISED DESCRIPTION

MEG
 MACON E. GOODRICH
 BUILDING CONTRACTORS
 1600 S. JEFFERSON ST.
 ALBANY, GEORGIA 31707
 TEL: 478-240-1111 FAX: 478-240-1116

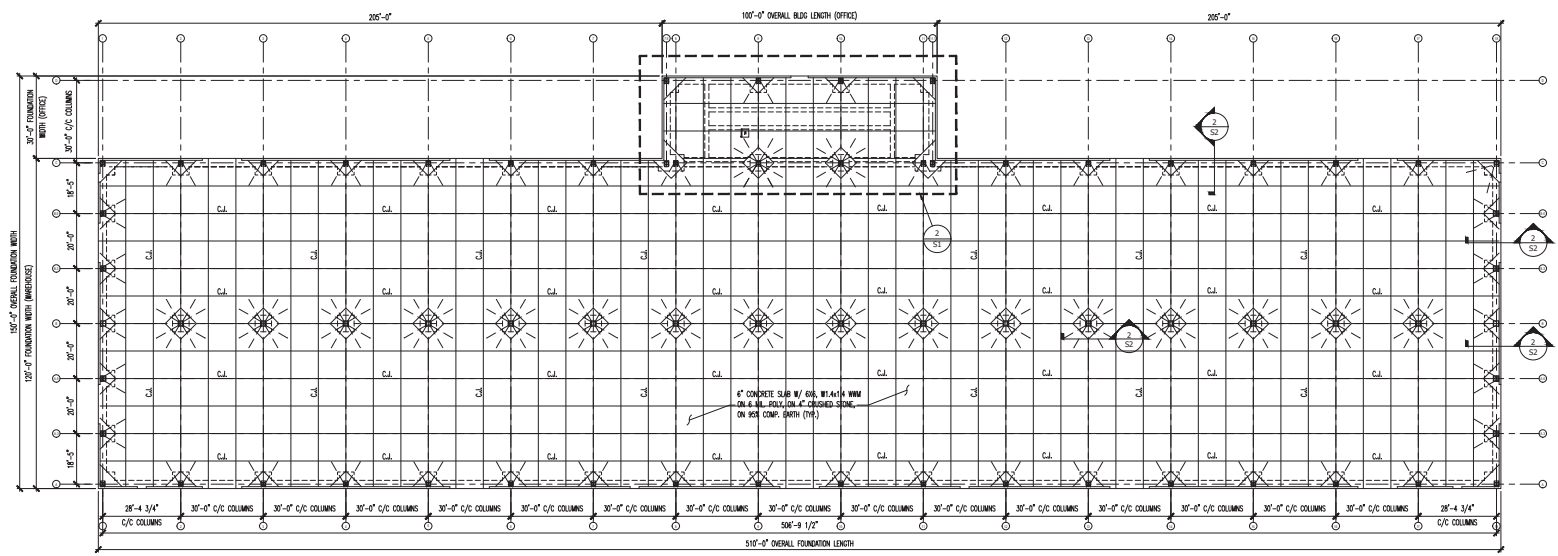

1 FOUNDATION PLAN
 S1 SCALE: 1/16"=1'-0"

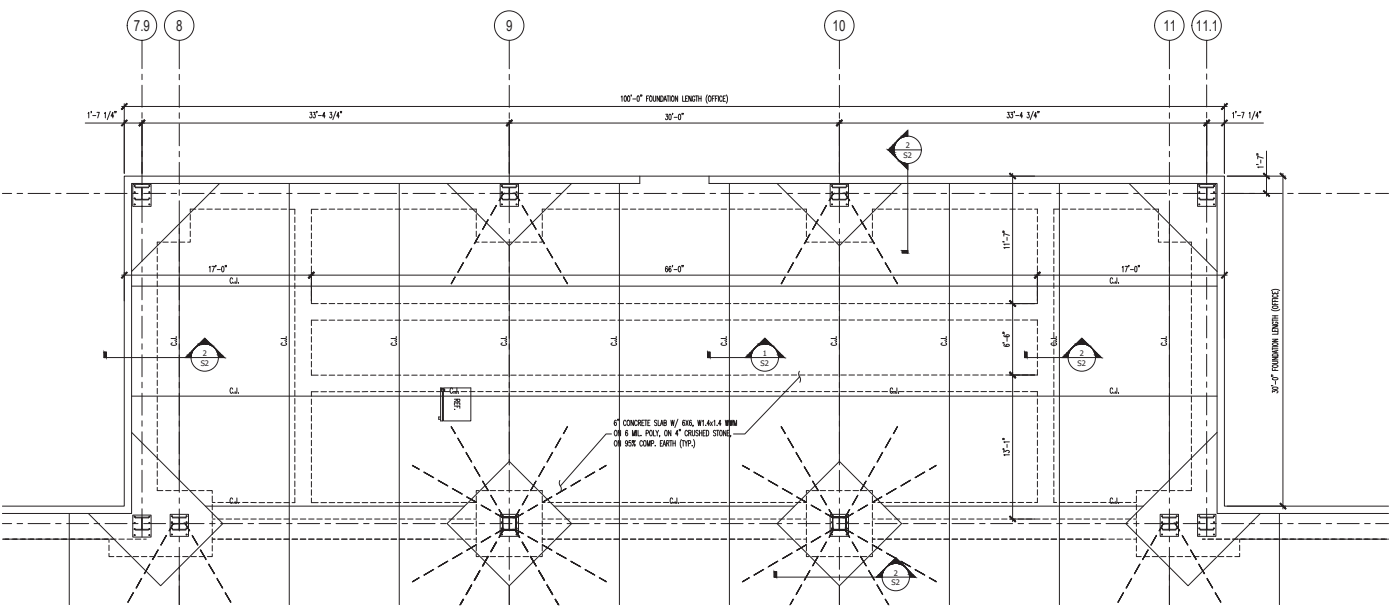

2 ENLARGED VIEW
 FOUNDATION PLAN (OFFICE)
 S1 SCALE: 1/4"=1'-0"









510x120 METAL BUILDING DESIGN
 LD WELDING SERVICES
 FOUNDATION PLAN
 28-37 ZONES
 4/28/24
 PROJECT # 0245189486
 HALL COUNTY, GEORGIA 30507

DESIGN	MEG	4/28/24
DRAWN	RSL	4/28/24
CHECKED	BSR	4/28/24
DATE		4/28/24
PROJECT #	0245189486	
SHEET	S1 OF XX	

NOT RELEASED FOR CONSTRUCTION

C:\Users\ludwick\appdata\local\temp\164766616.pdf; Path: C:\Users\ludwick\AppData\Local\Temp\164766616.pdf; Name: My... Drawing Set; P: 20-24.dwg; Th: 02/22/24 4:54 PM

C:\Users\candrea3\appdata\local\temp\Apublish_22432\2811 Athens Hwy - Drawing Set 8-20-24.dwg Thu, 08/22/24 4:54 PM

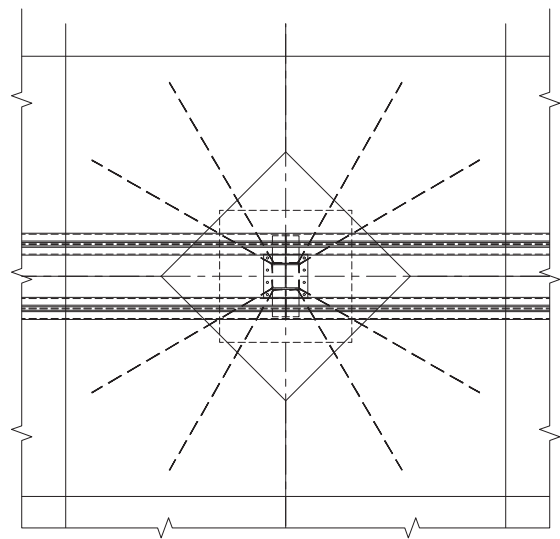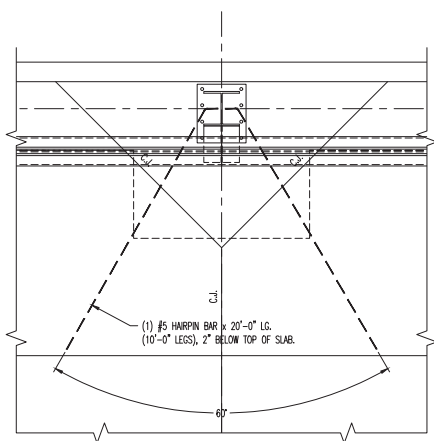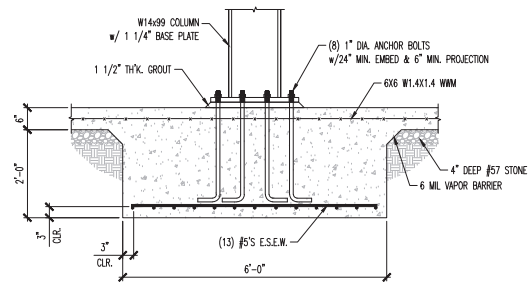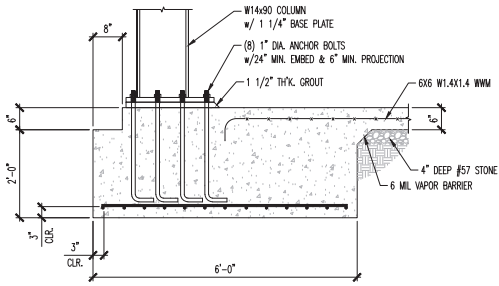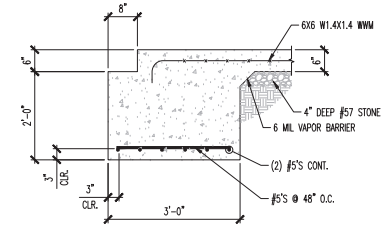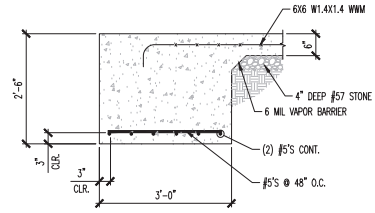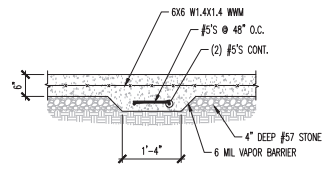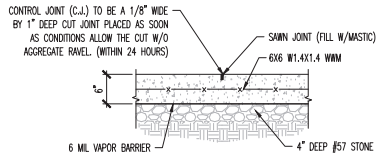

REVISION	DATE	APPROVED	DESCRIPTION

MACON E. GOOCH III
 BUILDING CONSULTANTS
 2811 ATHENS HWY
 ALBANY, GEORGIA 31707
 TEL: 678-442-1198 FAX: 678-295-7485

6/28/24


510'x120' METAL BUILDING DESIGN
 LD WELDING SERVICES
 FOUNDATION DETAILS
 2811 ATHENS HWY
 ALBANY, GEORGIA 31707

DESIGN	MEG	6/28/24
DRAWN	RSL	6/28/24
CHECKED	BSR	6/28/24
DATE:	6/28/24	
PROJECT #:	D240518948	


SHEET
 S2 OF X2

NOT RELEASED FOR CONSTRUCTION


C:\Users\cvaibee3\OneDrive\LocalTemp\A\Pub\sh_22432\2811 Athens Hwy - Drawing Set 8-20-24.dwg Thu, 08/22/24 4:54 PM

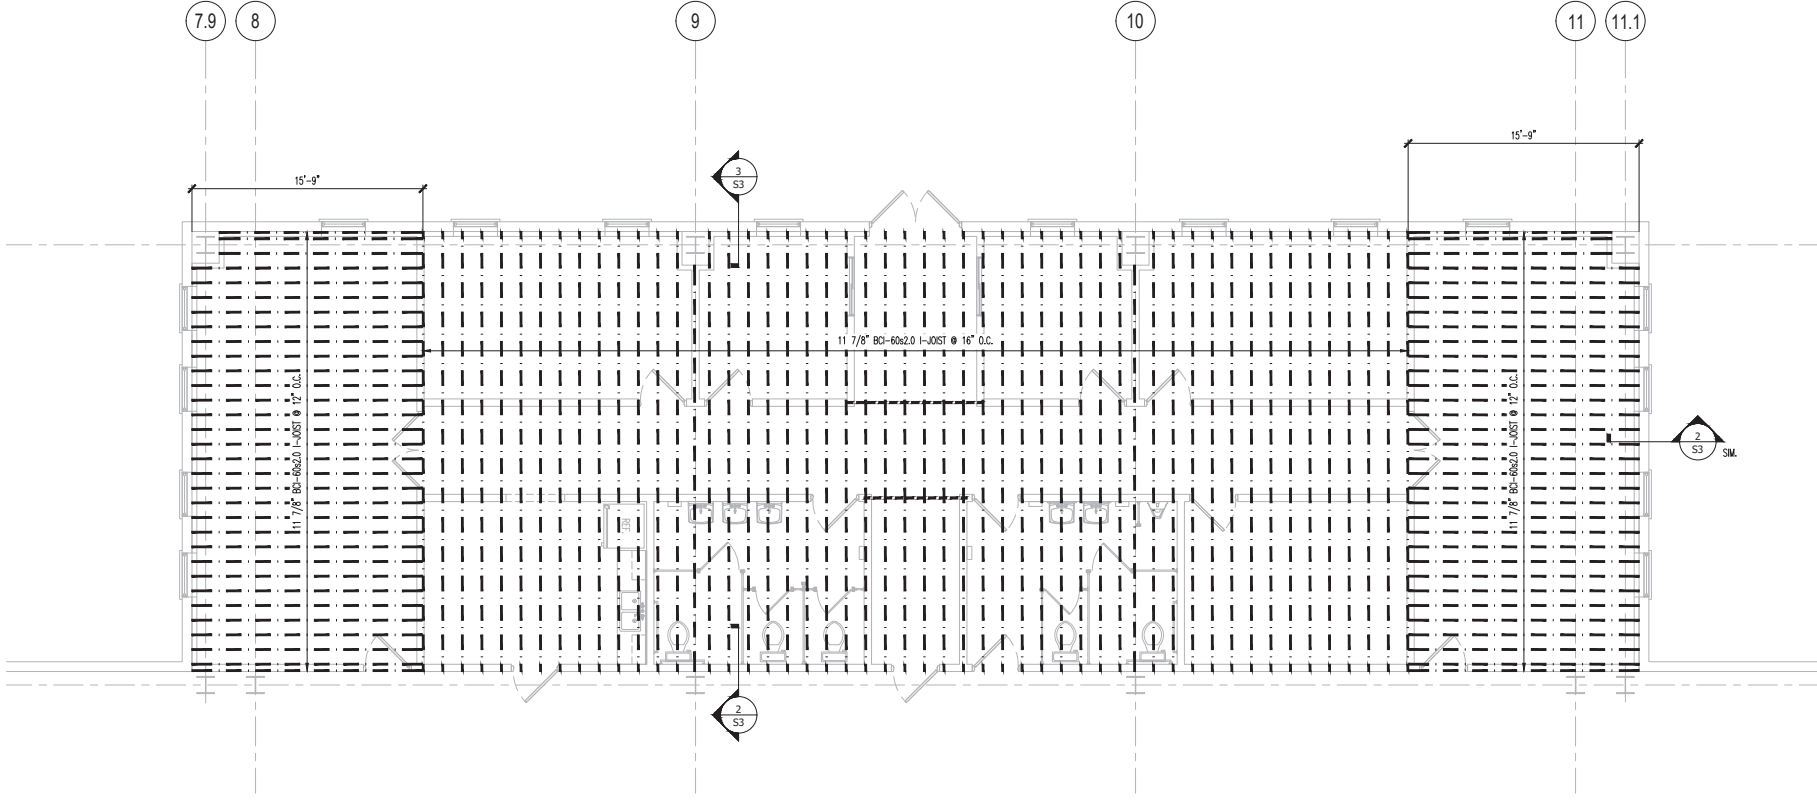

1 CEILING FRAMING PLAN (OFFICE)
 S3 SCALE: 1/4"=1'-0"

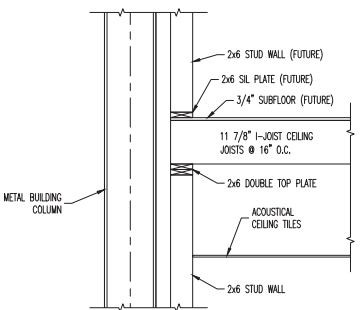

2 CEILING FRAMING DETAIL
 S3 SCALE: 3/4"=1'-0"

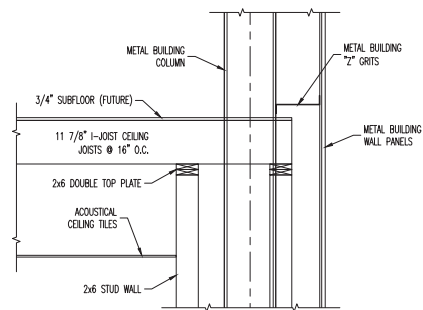

3 CEILING FRAMING DETAIL
 S3 SCALE: 3/4"=1'-0"

THESE CONSTRUCTION DOCUMENTS ARE PREPARED REPRESENTING IN WHOLE OR IN PART THE SOLE PROPERTY OF MEG AND THE SOLE PROPERTY OF MEG. NO PART OF THESE DOCUMENTS SHALL BE REPRODUCED, COPIED, EITHER WHOLLY OR IN PART, OR TRANSMITTED IN ANY FORM OR BY ANY MEANS, WITHOUT THE WRITTEN PERMISSION FROM MEG. THE USER OF THESE DOCUMENTS SHALL BE RESPONSIBLE FOR OBTAINING ALL NECESSARY PERMITS AND APPROVALS FROM ALL APPLICABLE AGENCIES. ALL RIGHTS RESERVED.

REVISION	DATE	APPROVED	DESCRIPTION

MACON E. GOOCH III
 BUILDING CONSULTANTS
 2811 ATHENS HWY
 ALBANY, GEORGIA 30507
 TEL: 678-442-1198 FAX: 678-295-7485

6/28/24

510'x120' METAL BUILDING DESIGN
 LD WELDING SERVICES
 CEILING FRAMING PLAN


2811 ATHENS HWY
 ALBANY, GA 30507
 2811 ATHENS HWY
 ALBANY, GA 30507

DESIGN	MEG	6/28/24
DRAWN	RSL	6/28/24
CHECKED	BSR	6/28/24
DATE:		6/28/24
PROJECT #:	D240518948	

SHEET
 S3 of X

NOT RELEASED FOR CONSTRUCTION

C:\Users\codest3\appdata\local\temp\AcPublish_22432\2811 Athens Hwy - Drawing Set 8-20-24.dwg Thu, 08/22/24 4:54 PM

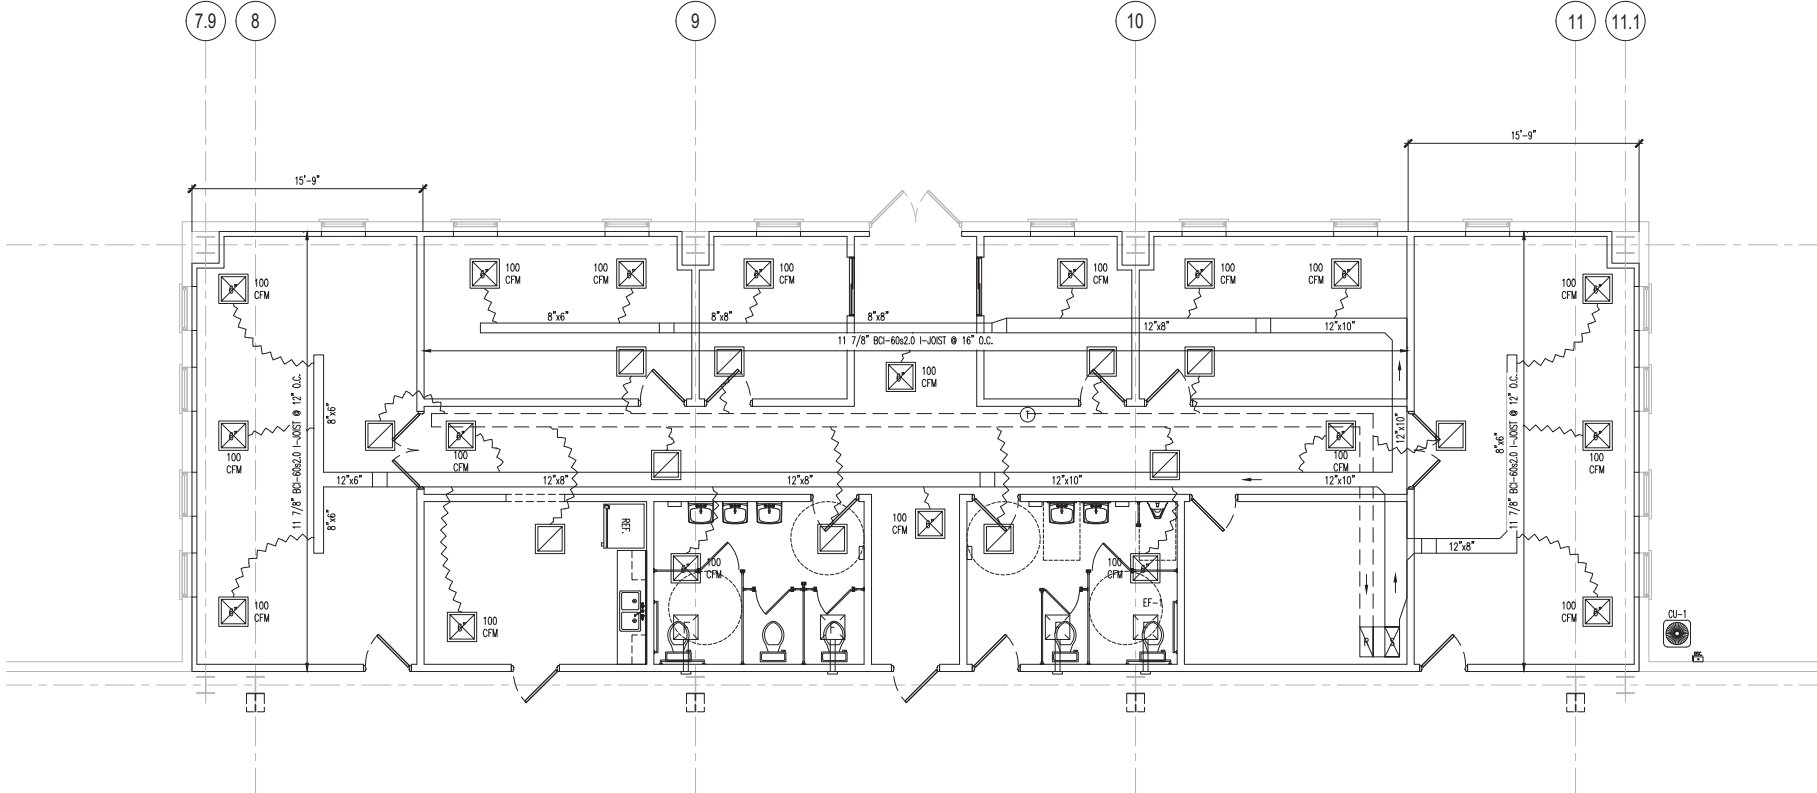

1 MECHANICAL PLAN (OFFICE)
M1 SCALE: 1/4"=1'-0"

MECHANICAL LEGEND	
SYMBOL	DESCRIPTION
	SUPPLY DIFFUSER - 2'x2'
	RETURN DIFFUSER - 2'x2'
	EXHAUST FAN
	RIGID DUCT (SIZE)
	FLEXIBLE DUCT
	PROGRAMMABLE THERMOSTAT, 54" A.F.F.

REVISION	DATE	APPROVED	DESCRIPTION

MACON E. GOOCH III
BUILDING CONSULTANTS
ALBANY, GEORGIA 31701
TEL: 678-442-1198 FAX: 678-295-7485

510'x120' METAL BUILDING DESIGN
LD WELDING SERVICES
MECHANICAL PLAN - OFFICE

2811 ATHENS HWY
HALL COUNTY, GEORGIA 30507

DESIGN	MEG	6/28/24
DRAWN	RSL	6/28/24
CHECKED	BSR	6/28/24
DATE:	6/28/24	
PROJECT #:	D240518948	

1 of X

NOT RELEASED FOR CONSTRUCTION

1
M1 MECHANICAL PLAN (OFFICE)
SCALE: 1/4"=1'-0"

MECHANICAL LEGEND	
SYMBOL	DESCRIPTION
	SUPPLY DIFFUSER - 2'x2'
	RETURN DIFFUSER - 2'x2'
	EXHAUST FAN
	RIDGED DUCT (SIZE)
	FLEXIBLE DUCT
	PROGRAMMABLE THERMOSTAT, 5A" A.F.F.

NOT RELEASED FOR CONSTRUCTION

510'x120' METAL BUILDING DESIGN
LD WELDING SERVICES
MECHANICAL DETAILS

2811 ATHENS HWY
HALL COUNTY, GEORGIA 30507


DESIGN	MEG	6/28/24
DRAWN	RSL	6/28/24
CHECKED	BSR	6/28/24
DATE:	6/28/24	
PROJECT #:	D240518948	

SHEET
M2 OF X

MEG
MACON E. GOOCH III
BUILDING CONSULTANTS
1000 W. BROADWAY
ALBANY, GEORGIA 31701
TEL: 678-442-1198 FAX: 678-295-7485

REVISION	DATE	APPROVED	DESCRIPTION

THESE CONSTRUCTION DOCUMENTS ARE PREPARED REPRESENTING IN WHOLE OR IN PART THE SOLE PROPERTY OF MACON E. GOOCH III BUILDING CONSULTANTS. NO PART OF THESE DOCUMENTS SHALL BE REPRODUCED, COPIED, EITHER WHOLLY OR IN PART, OR TRANSMITTED IN ANY MANNER, WITHOUT THE WRITTEN PERMISSION FROM MACON E. GOOCH III BUILDING CONSULTANTS. ALL RIGHTS RESERVED.

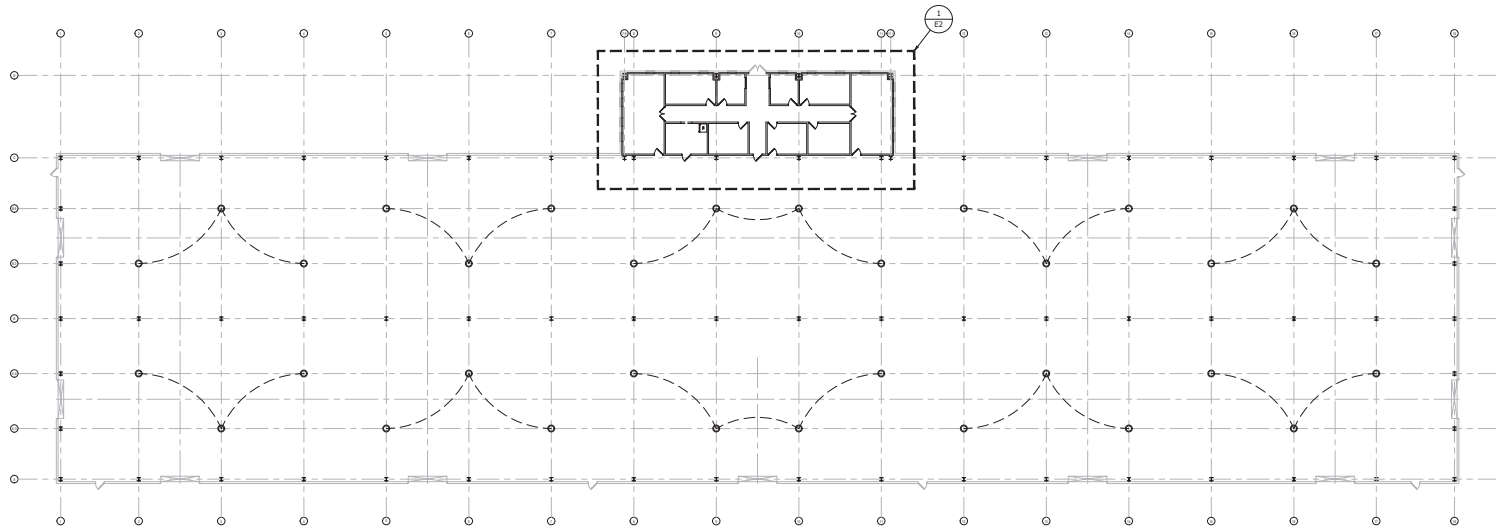

E1 LIGHTING PLAN (WAREHOUSE)
SCALE: 1/16"=1'-0"

ELECTRICAL LEGEND	
SYMBOLS	DESCRIPTION
○	RECESSED INCANDESCENT LIGHT
⊕	SURFACE MOUNTED LIGHT FIXTURE
⊕	WALL MOUNTED LIGHT FIXTURE
⊕	DUPLEX RECEPTACLE
⊕	DUPLEX RECEPTACLE, 42" A.F.F.
⊕	120V GROUND FAULT INTERRUPTER
⊕	240V RECEPTACLE
S	WALL SWITCH, SINGLE POLE, 120/277V, QUIET TYPE 44" A.F.F. OR AS NOTED
S ₃	WALL SWITCH, 3 WAY, 120/277V, QUIET TYPE 44" A.F.F. OR AS NOTED
S ₄	WALL SWITCH w/ MOTION SENSOR, SINGLE POLE, 120/277V, QUIET TYPE 44" A.F.F. OR AS NOTED
⊕	EXHAUST FAN, VENTED TO OUTSIDE
⊕	EMERGENCY EXIT LIGHT/SIGN, WALL MOUNTED
⊕	EMERGENCY EXIT LIGHT/SIGN, CEILING MOUNTED
○	HIGH BAY LED LIGHTING, 240 WATT, 32,000 LUMEN, 120V/60Hz
○	1x4 LED LIGHT FIXTURE
□	2x2 LED LIGHT FIXTURE
---	HOME RUN CIRCUIT TO PANEL, "1/2" OR "3/4"

NO.	REVISION	DATE	BY	DESCRIPTION

MEG
 MACON E. GOUGH III
 LICENSED PROFESSIONAL ENGINEER
 - ELECTRICAL -
 LICENSE NO. 12483
 2150 W. BROADWAY, SUITE 200
 MACON, GA 31204-1100
 TEL: 478-244-1100 FAX: 478-244-1106

6/28/24

510x120 METAL BUILDING DESIGN
 LD WELDING SERVICES
 LIGHTING PLAN - WAREHOUSE
 2847 ZION ROAD
 MACON, GA 31204
 HALL COUNTY, GEORGIA 30507


DESIGN	MEG	6/28/24
DRAWN	RSJ	6/28/24
CHECKED	BSR	6/28/24
DATE:	6/28/24	
PROJECT #:	02405194486	
SHEET	E1 of XX	

NOT RELEASED FOR CONSTRUCTION

E1 of XX

C:\Users\jordan\OneDrive\Documents\Projects\510x120 Metal Building Design\510x120 Metal Building Design - Warehouse - Lighting Plan - Warehouse.dwg, 6/28/24, 4:54 PM

C:\Users\candrea3\appdata\local\temp\AcPublish_22432\2811 Athens Hwy - Drawing Set 8-20-24.dwg Thu, 08/22/24 4:54 PM

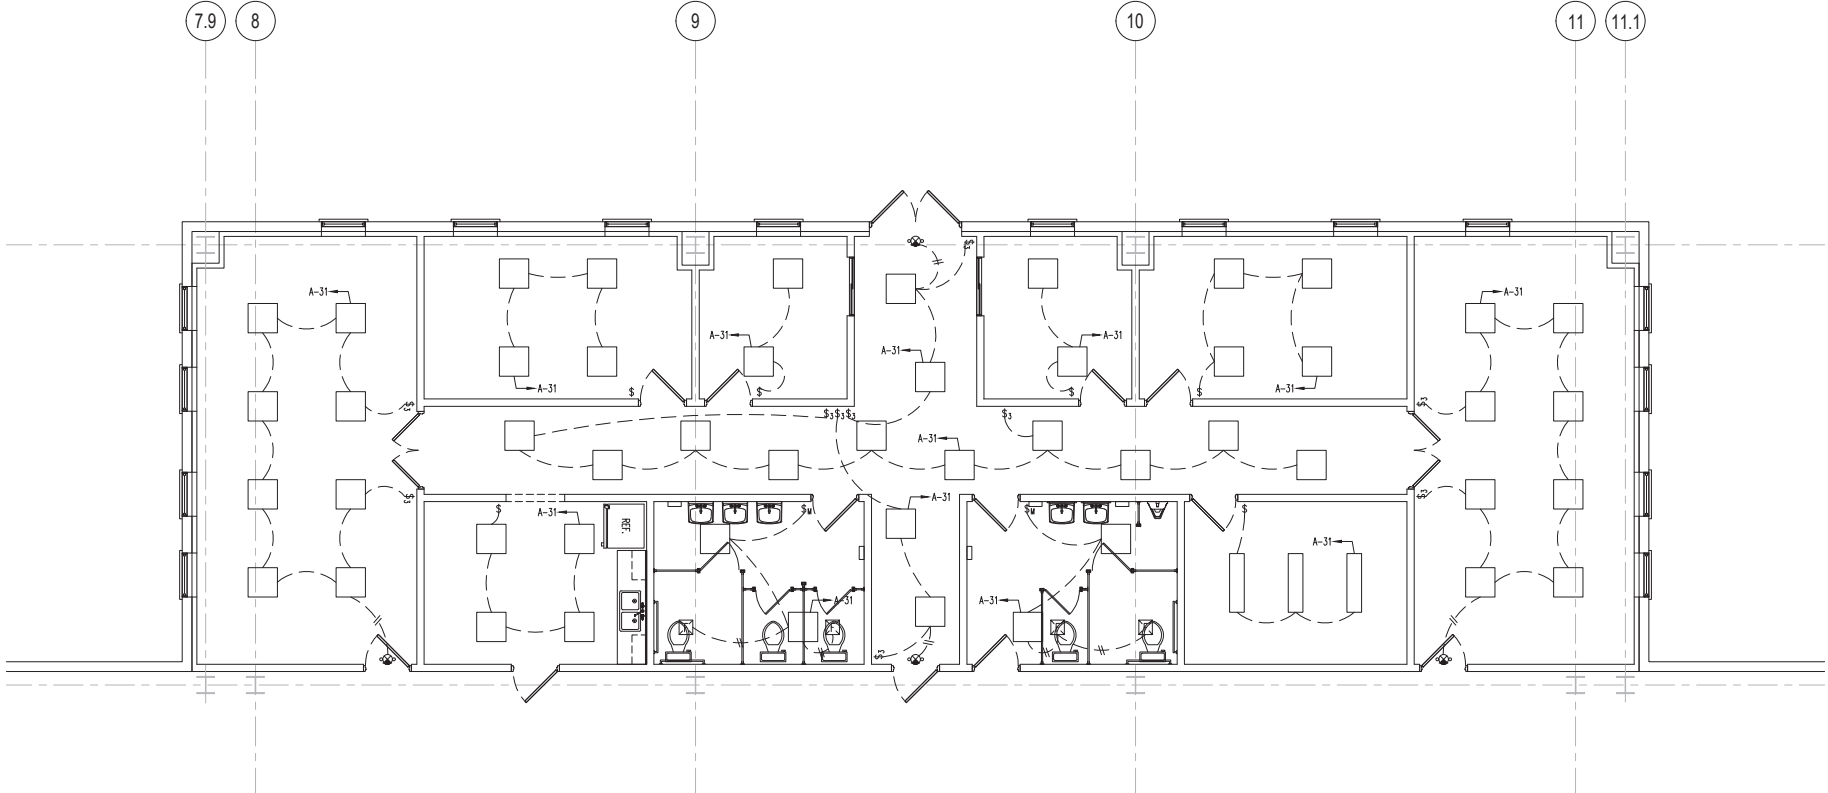

1 LIGHTING PLAN (OFFICE)
E2 SCALE: 1/4"=1'-0"

LIGHTING LEGEND	
SYMBOLS	DESCRIPTION
○	RECESSED INCANDESCENT LIGHT
⊕	WALL MOUNTED LIGHT FIXTURE
\$	WALL SWITCH, SINGLE POLE, 120/277V, QUIET TYPE 44" A.F.F. OR AS NOTED
\$3	WALL SWITCH, 3 WAY, 120/277V, QUIET TYPE 44" A.F.F. OR AS NOTED
\$w	WALL SWITCH w/ MOTION SENSOR, SINGLE POLE, 120/277V, QUIET TYPE 44" A.F.F. OR AS NOTED
⊞	EXHAUST FAN, VENTED TO OUTSIDE
⊞	EMERGENCY EXIT LIGHT/SIGN, CEILING MOUNTED
□	1x4 LED LIGHT FIXTURE
→	HOME RUN CIRCUIT TO PANEL "LIC" OR "PWR"

NOT RELEASED FOR CONSTRUCTION

REASON	DATE	APPROVED	DESCRIPTION


MACON E. GOOCH III
BUILDING CONSULTANTS
ALBANY, GEORGIA 31701
TEL: 678-442-1198 FAX: 678-295-7485

6/28/24

510'x120' METAL BUILDING DESIGN
LD WELDING SERVICES
LIGHTING PLAN - OFFICE
2811 ATHENS HWY
HALL COUNTY, GEORGIA 30507

DESIGN	MEG	6/28/24
DRAWN	RSL	6/28/24
CHECKED	BSR	6/28/24
DATE:	6/28/24	
PROJECT #:	D2405189486	
SHEET	E2 of XX	

C:\Users\candrea3\OneDrive\LocalTemp\Apublish_22432\2811 Athens Hwy - Drawing Set 8-20-24.dwg Thu, 08/22/24 4:54 PM

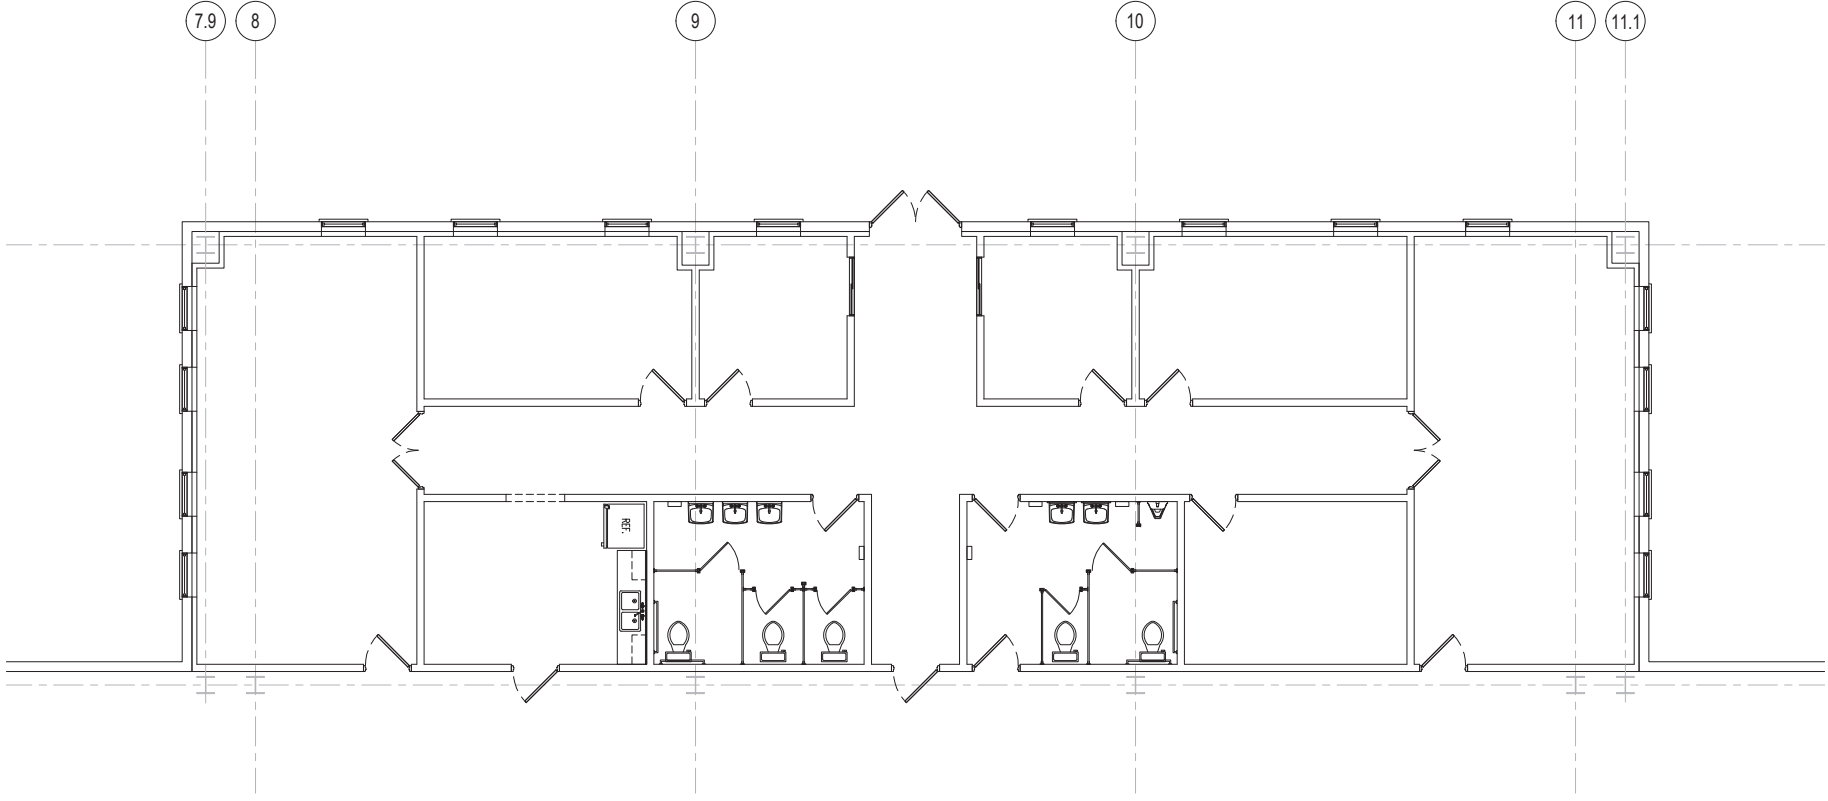

1 POWER PLAN (OFFICE)
E3 SCALE: 1/4"=1'-0"

THESE CONSTRUCTION DOCUMENTS ARE PREPARED REPRESENTING IN WHOLE OR IN PART THE PROFESSIONAL SERVICE OF MEG AND THE SOLE PROPERTY OF MEG. NO PART OF THESE DOCUMENTS SHALL BE REPRODUCED, COPIED, EITHER WHOLLY OR IN PART, OR TRANSMITTED IN ANY FORM OR BY ANY MEANS, WITHOUT THE WRITTEN PERMISSION OF MEG. CONSULTANTS SHALL BE RESPONSIBLE FOR OBTAINING ALL NECESSARY PERMITS AND APPROVALS.

REVISION	DATE	APPROVED	DESCRIPTION

MEG
 MACON E. GOOCH III
 BUILDING CONSULTANTS
 2811 ATHENS HWY
 ALBANY, GEORGIA 31707
 TEL: 678-442-1198 FAX: 678-295-7485


6/28/24

510'x120' METAL BUILDING DESIGN
LD WELDING SERVICES
LIGHTING PLAN - OFFICE
 2811 ATHENS HWY
 HALL COUNTY, GEORGIA 30507

DESIGN	MEG	6/28/24
DRAWN	RSL	6/28/24
CHECKED	BSR	6/28/24
DATE:	6/28/24	
PROJECT #:	D2405189486	
SHEET	E3 of XX	

NOT RELEASED FOR CONSTRUCTION

C:\Users\cortea3\OneDrive\Local Temp\Acpublish_22432\2811 Athens Hwy - Drawing Set 8-20-24.dwg Thu, 08/22/24 4:54 PM

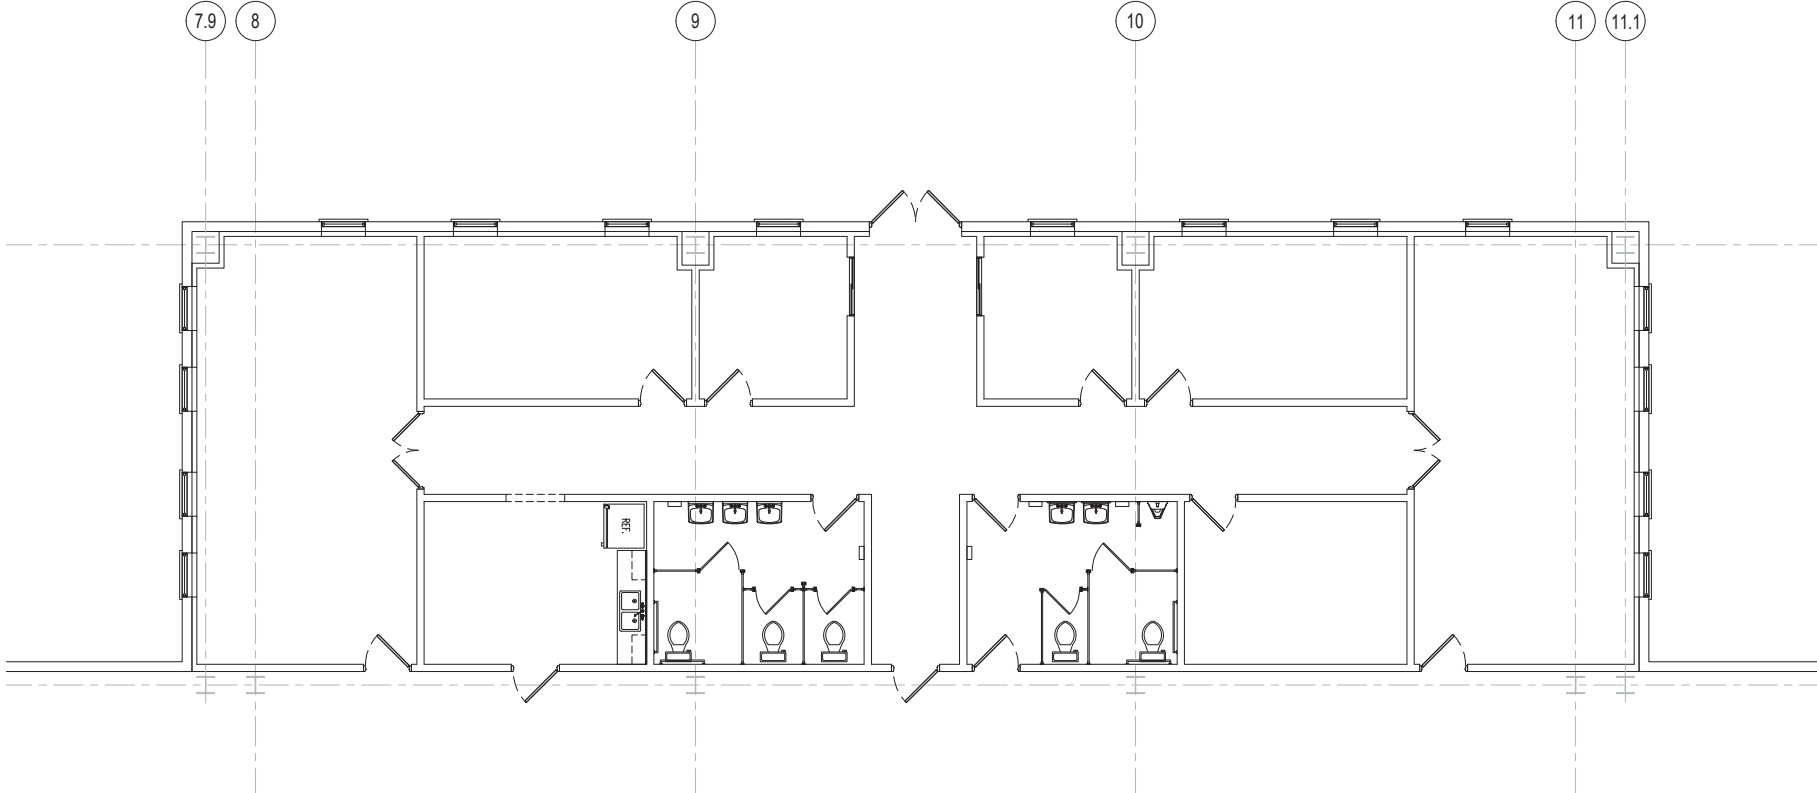

1 PLUMBING PLAN - SUPPLY (OFFICE)
 P2 SCALE: 1/4"=1'-0"

THESE CONSTRUCTION DOCUMENTS ARE PREPARED REPRESENTING IN WHOLE OR IN PART THE PROFESSIONAL SERVICE OF MEG AND THE SOLE PROPERTY OF MEG. NO PART OF THESE DOCUMENTS SHALL BE REPRODUCED, COPIED, STORED, TRANSMITTED, OR OTHERWISE MADE PUBLIC IN ANY MANNER WITHOUT THE WRITTEN CONSENT OF MEG. ANY OTHER PROJECTS OTHER THAN THAT AUTHORIZED BY MEG SHALL BE THE SOLE PROPERTY OF MEG. MEG SHALL NOT BE RESPONSIBLE FOR ANY ERRORS OR OMISSIONS IN ANY DOCUMENTS PREPARED BY OTHER CONSULTANTS. MEG CONSULTANTS SHALL BE RESPONSIBLE FOR THE ACCURACY OF THE INFORMATION PROVIDED HEREIN. ALL RIGHTS RESERVED.

REVISION	DATE	APPROVED	DESCRIPTION


MACON E. GOOCH III
 BUILDING CONSULTANTS
 ALBANY, GEORGIA 31701
 TEL: 678-442-1198 FAX: 678-205-7485

6/28/24

510'x120' METAL BUILDING DESIGN
 LD WELDING SERVICES
 PLUMBING PLAN - SUPPLY (OFFICE)
 2811 ATHENS HWY
 HALL COUNTY, GEORGIA 30507

DESIGN	MEG	6/28/24
DRAWN	RSL	6/28/24
CHECKED	BSR	6/28/24
DATE:	6/28/24	
PROJECT #:	D2405189486	
SHEET	P2 of XX	

NOT RELEASED FOR CONSTRUCTION

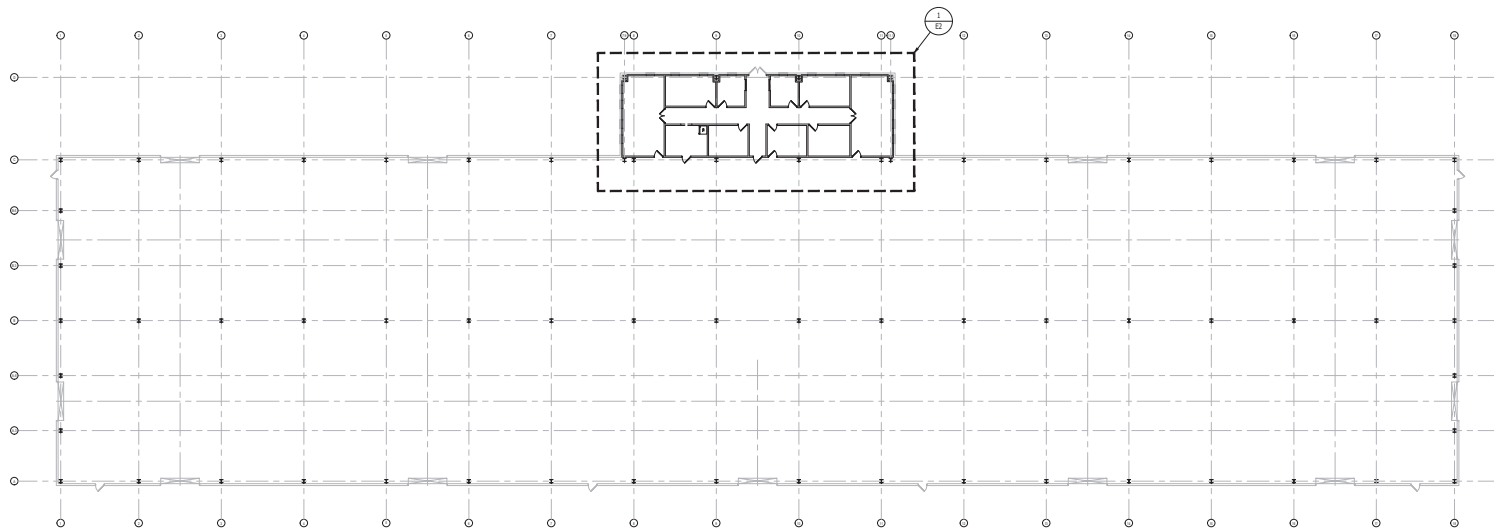

1 PLUMBING PLAN - WASTE WATER (WAREHOUSE)
 P3 SCALE: 1/16"=1'-0"

ELECTRICAL LEGEND	
SYMBOLS	DESCRIPTION
○	RECESSED INCANDESCENT LIGHT
⊕	SURFACE MOUNTED LIGHT FIXTURE
⊕H	WALL MOUNTED LIGHT FIXTURE
⊕D	DUPLEX RECEPTACLE
⊕D	DUPLEX RECEPTACLE, 42" A.F.F.
⊕G	120V GROUND FAULT INTERRUPTER
⊕H	240V RECEPTACLE
S	WALL SWITCH, SINGLE POLE, 120/277V, QUIET TYPE 44" A.F.F. OR AS NOTED
S ₃	WALL SWITCH, 3 WAY, 120/277V, QUIET TYPE 44" A.F.F. OR AS NOTED
S _M	WALL SWITCH w/ MOTION SENSOR, SINGLE POLE, 120/277V, QUIET TYPE 44" A.F.F. OR AS NOTED
⊕E	EXHAUST FAN, VENTED TO OUTSIDE, WALL MOUNTED
⊕E	EMERGENCY EXIT LIGHT/SIGN, WALL MOUNTED
⊕E	EMERGENCY EXIT LIGHT/SIGN, CEILING MOUNTED
○	HIGH BAY LED LIGHTING, 240 WATT, 32,000 LUMEN, 120V/60Hz
□	1x4 LED LIGHT FIXTURE
□	2x2 LED LIGHT FIXTURE
---	HOME RUN CIRCUIT TO PANEL, 1/2" OR 3/4"

NO.	REVISION	DATE	BY	DESCRIPTION


MASON E. GOUGH III
 LICENSED PROFESSIONAL ENGINEER
 PLUMBING
 2811 ATHENS HWY
 HALL COUNTY, GEORGIA 30507
 TEL: 706-526-1100 FAX: 706-526-1106

6/28/24

510x120 METAL BUILDING DESIGN
 LD WELDING SERVICES
PLUMBING PLAN - WASTE WATER (WAREHOUSE)
 2811 ATHENS HWY
 HALL COUNTY, GEORGIA 30507

DESIGN	MEG	6/28/24
DRAWN	RSJ	6/28/24
CHECKED	BSR	6/28/24
DATE:	6/28/24	
PROJECT #:	02405189486	


SHEET

NOT RELEASED FOR CONSTRUCTION

P3 of XX

C:\Users\jacobm\OneDrive\Documents\jacobm\p3\p3\p3.dwg Thu, 06/28/24 4:54 PM

C:\Users\conradh3\AppData\Local\Temp\AcPublish_22432\281 Athens Hwy - Drawing Set 8-20-24.dwg Thu, 08/22/24 4:54 PM

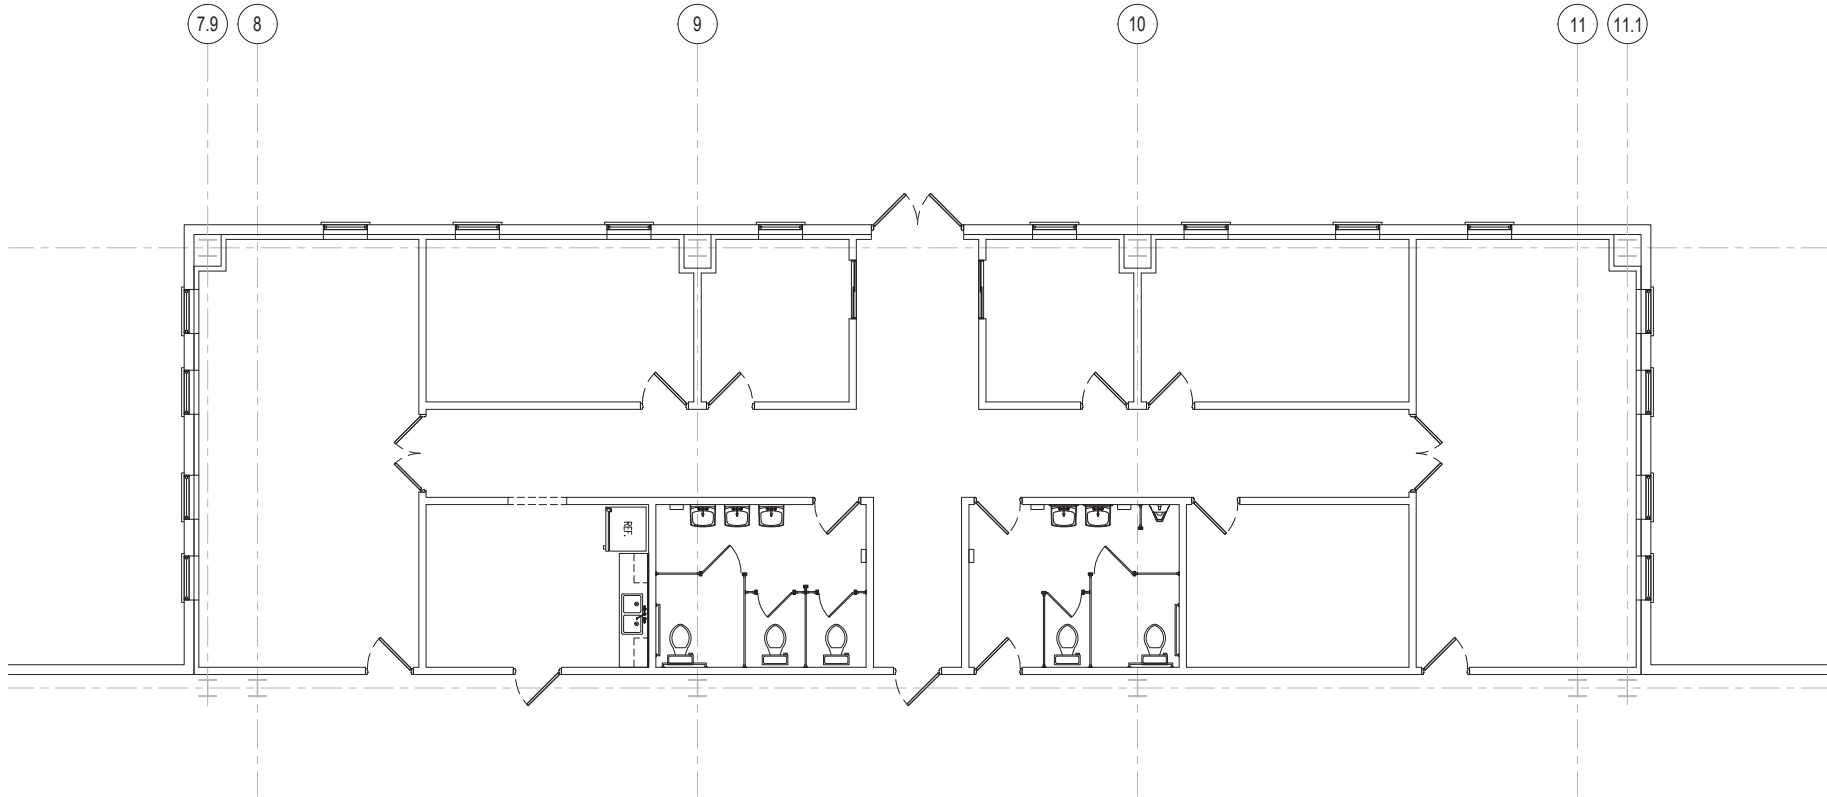


1 PLUMBING PLAN - WASTE WATER (OFFICE)
P4 SCALE: 1/4"=1'-0"

NOT RELEASED FOR CONSTRUCTION

THESE CONSTRUCTION DOCUMENTS ARE PREPARED REPRESENTING IN WHOLE OR IN PART THE PROFESSIONAL SERVICE OF MEG AND THE SOLE PROPERTY OF MACON E. GOOCH III BUILDING CONSULTANTS. NO PART OF THESE DOCUMENTS SHALL BE REPRODUCED OR TRANSMITTED IN ANY FORM OR BY ANY MEANS, ELECTRONIC OR MECHANICAL, INCLUDING PHOTOCOPYING, RECORDING, OR BY ANY INFORMATION STORAGE AND RETRIEVAL SYSTEM, WITHOUT THE WRITTEN PERMISSION FROM MEG AND THE BUILDING CONSULTANTS. NO OTHER PROJECTS OTHER THAN THAT SPECIFICALLY IDENTIFIED IN THESE DOCUMENTS SHALL BE PERMITTED WITHOUT THE WRITTEN PERMISSION FROM MEG AND THE BUILDING CONSULTANTS. ALL RIGHTS RESERVED.

REVISION	DATE	APPROVED	DESCRIPTION

MACON E. GOOCH III
BUILDING CONSULTANTS
ALBANY, GEORGIA 3001
TEL: 678-442-1198 FAX: 678-295-7485



6/28/24

510'x120' METAL BUILDING DESIGN
LD WELDING SERVICES
PLUMBING PLAN - WASTE WATER (OFFICE)
2811 ATHENS HWY
HALL COUNTY, GEORGIA 30507

DESIGN	MEG	6/28/24
DRAWN	RSL	6/28/24
CHECKED	BSR	6/28/24
DATE:	6/28/24	
PROJECT #:	D2405189486	

SHEET
P4 of XX